
 
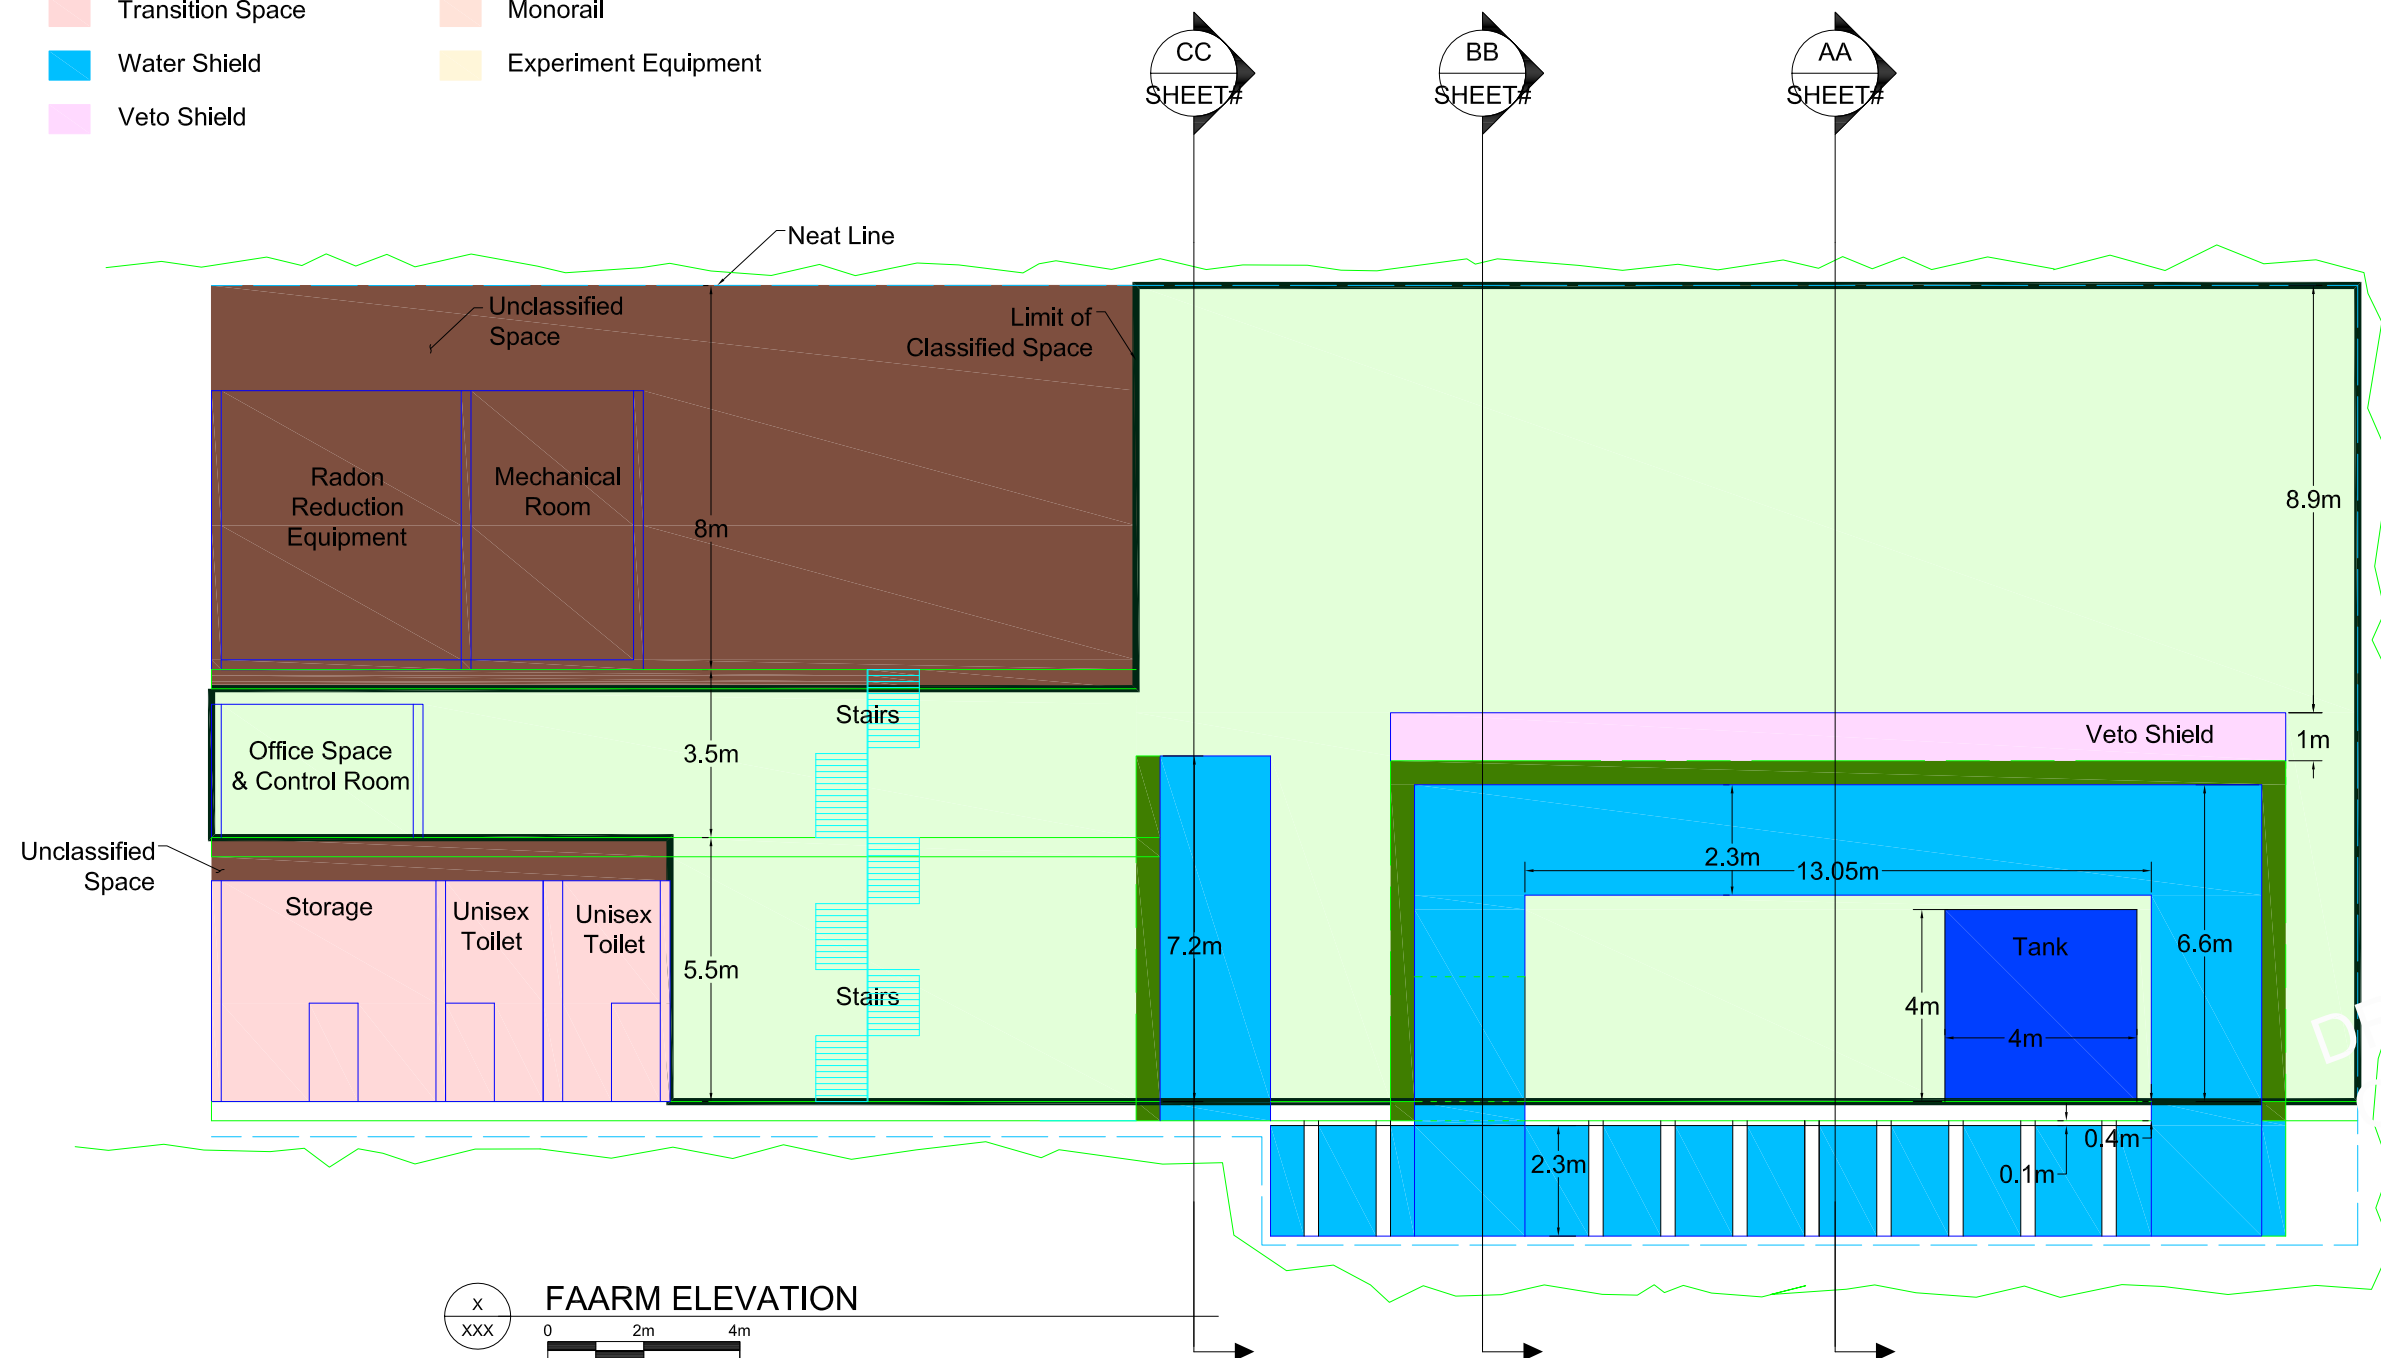



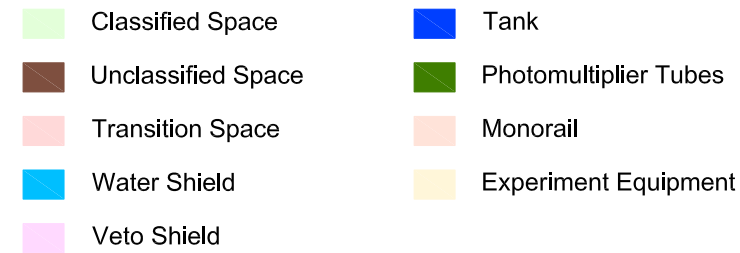

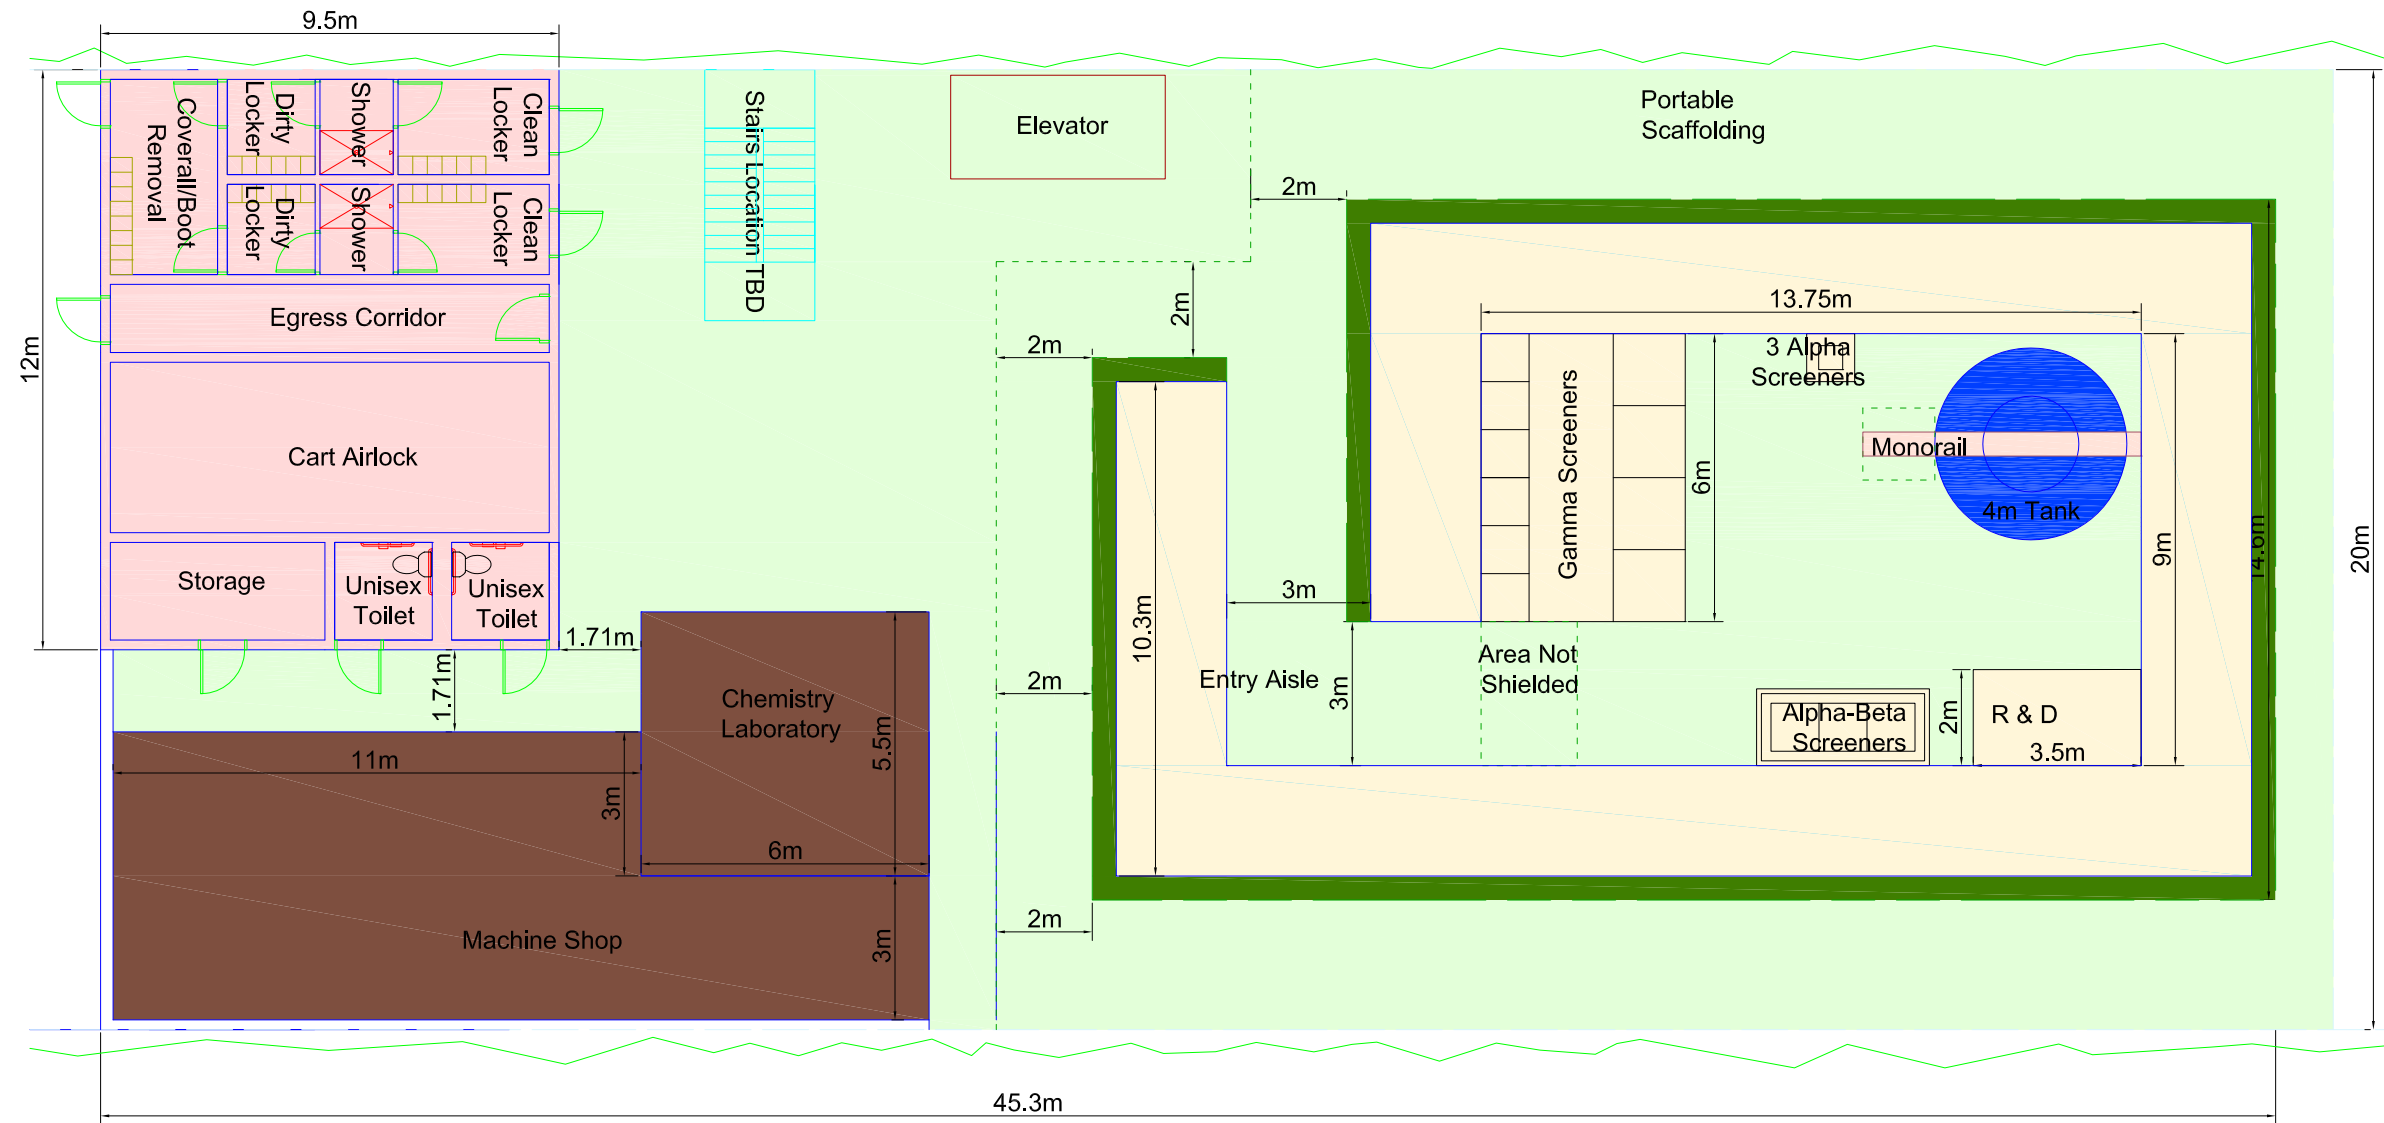

FAARM FIRST FLOOR PLAN

Signature _____
X _____
Name _____
X _____
Date _____ License # _____

PROJECT: _____

UNIVERSITY OF MN

FAARM

CITY, STATE

REVISED:		
NO.	DATE	REMARK
#	#	#
#	#	#
#	#	#
#	#	#
#	#	#
#	#	#
#	#	#

COMM. NO.2 CNA0902

DATE: NOVEMBER 19, 2009

DRAWN: XXX

CHECKED: XXX

DRAWING TITLE: _____

DRAWING NUMBER: _____

####

- Classified Space

Unclassified Space

Transition Space


Water Shield

Veto Shield
- Tank

Photomultiplier Tubes

Monorail

Experiment Equipment

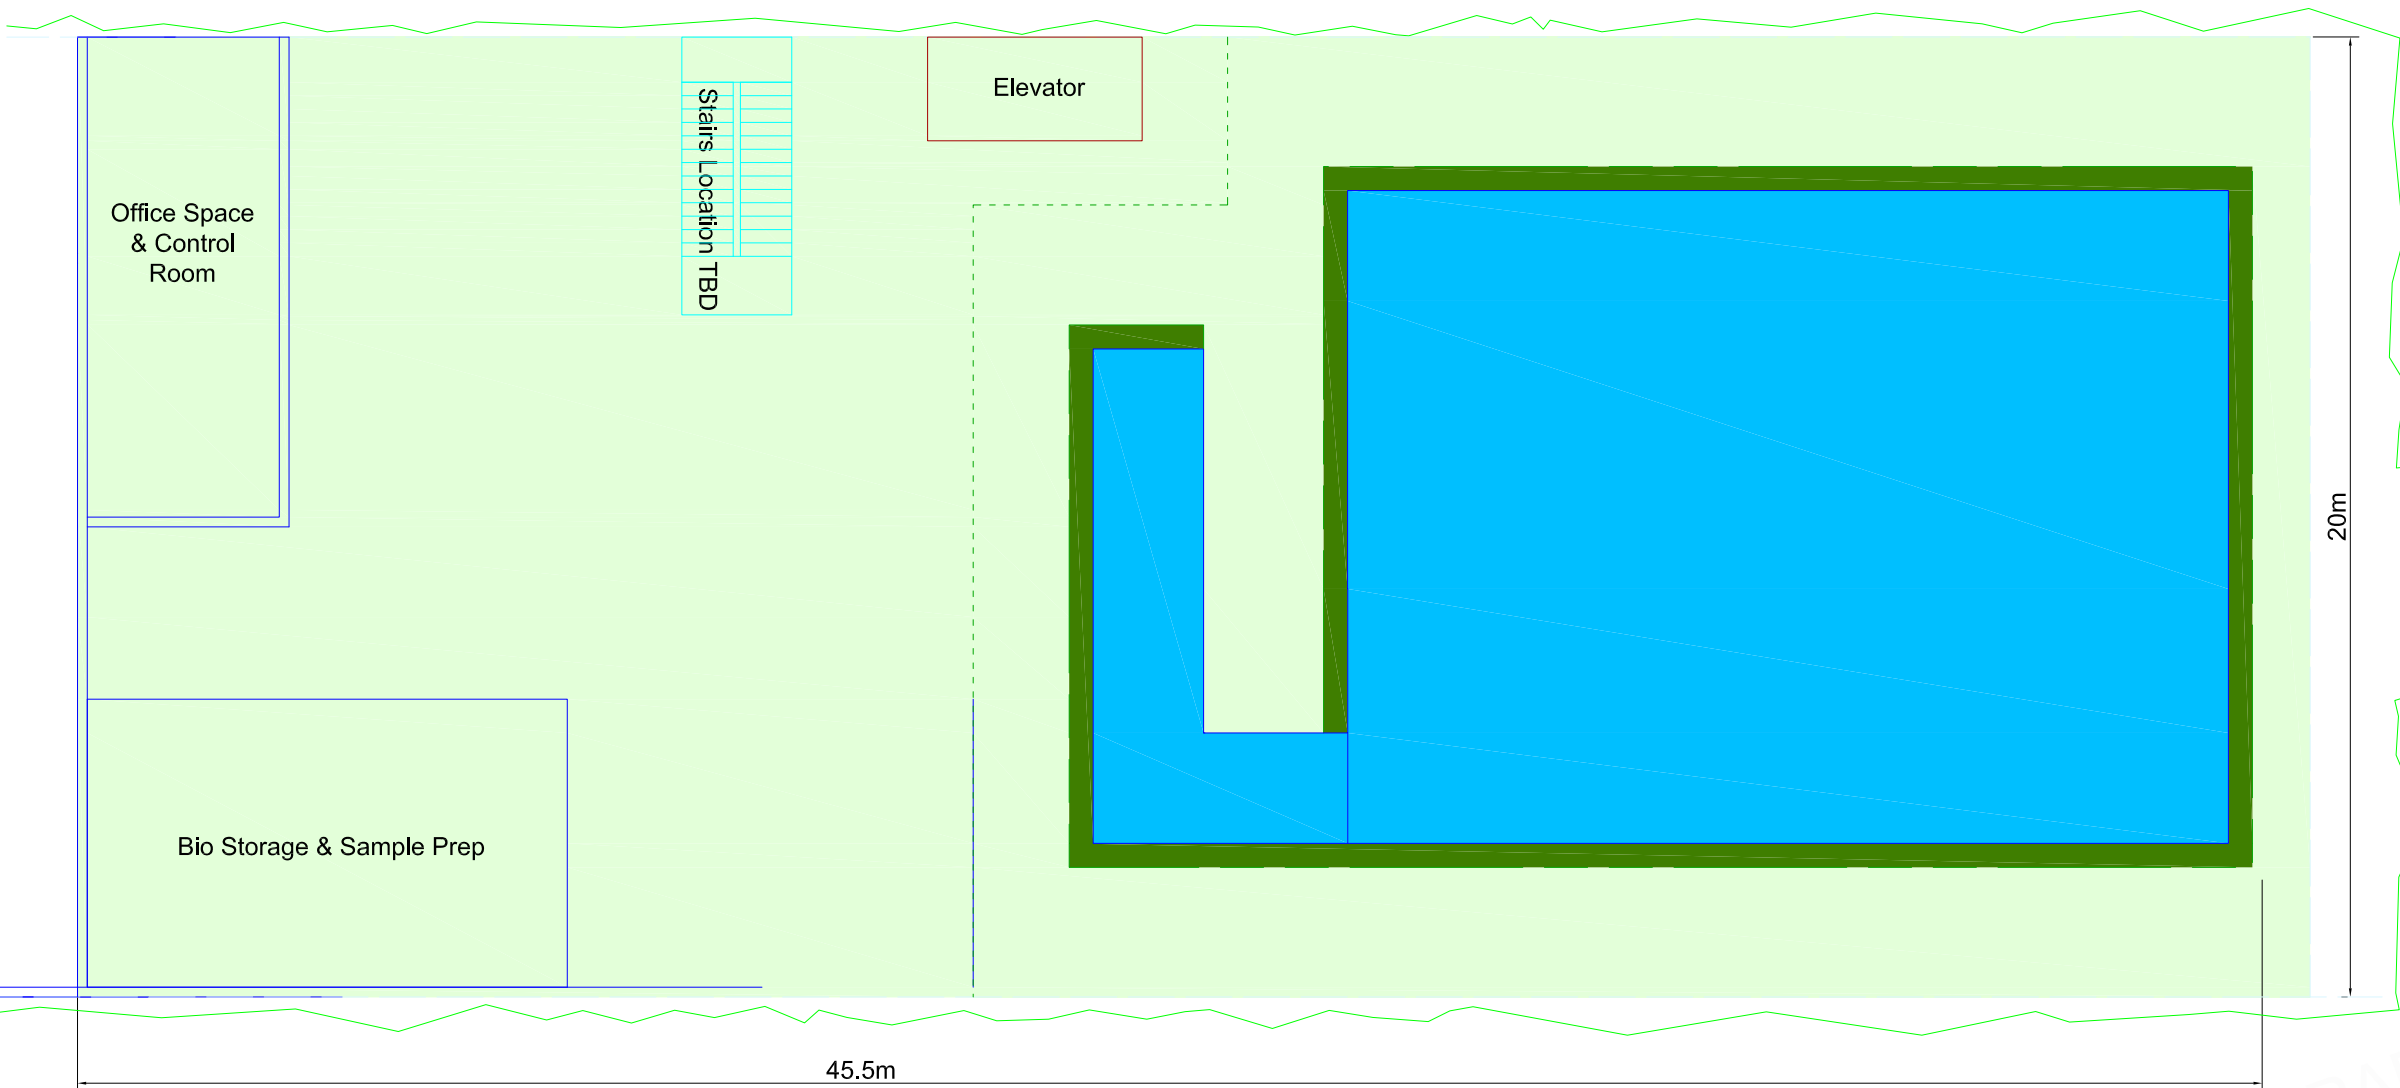

FAARM SECOND FLOOR PLAN

Signature _____
X _____
Name _____
X _____
Date _____ License # _____

PROJECT: _____

UNIVERSITY OF MN

FAARM

CITY, STATE

REVISED:		
NO.	DATE	REMARK
#	#	#
#	#	#
#	#	#
#	#	#
#	#	#
#	#	#
#	#	#
#	#	#

COMM. NO.2 _____ CNA0902
DATE: _____ NOVEMBER 19, 2009
DRAWN: _____ XXX
CHECKED: _____ XXX

DRAWING TITLE: _____

DRAWING NUMBER: _____

####

- Classified Space

Unclassified Space

Transition Space


Water Shield

Veto Shield
- Tank

Photomultiplier Tubes

Monorail

Experiment Equipment

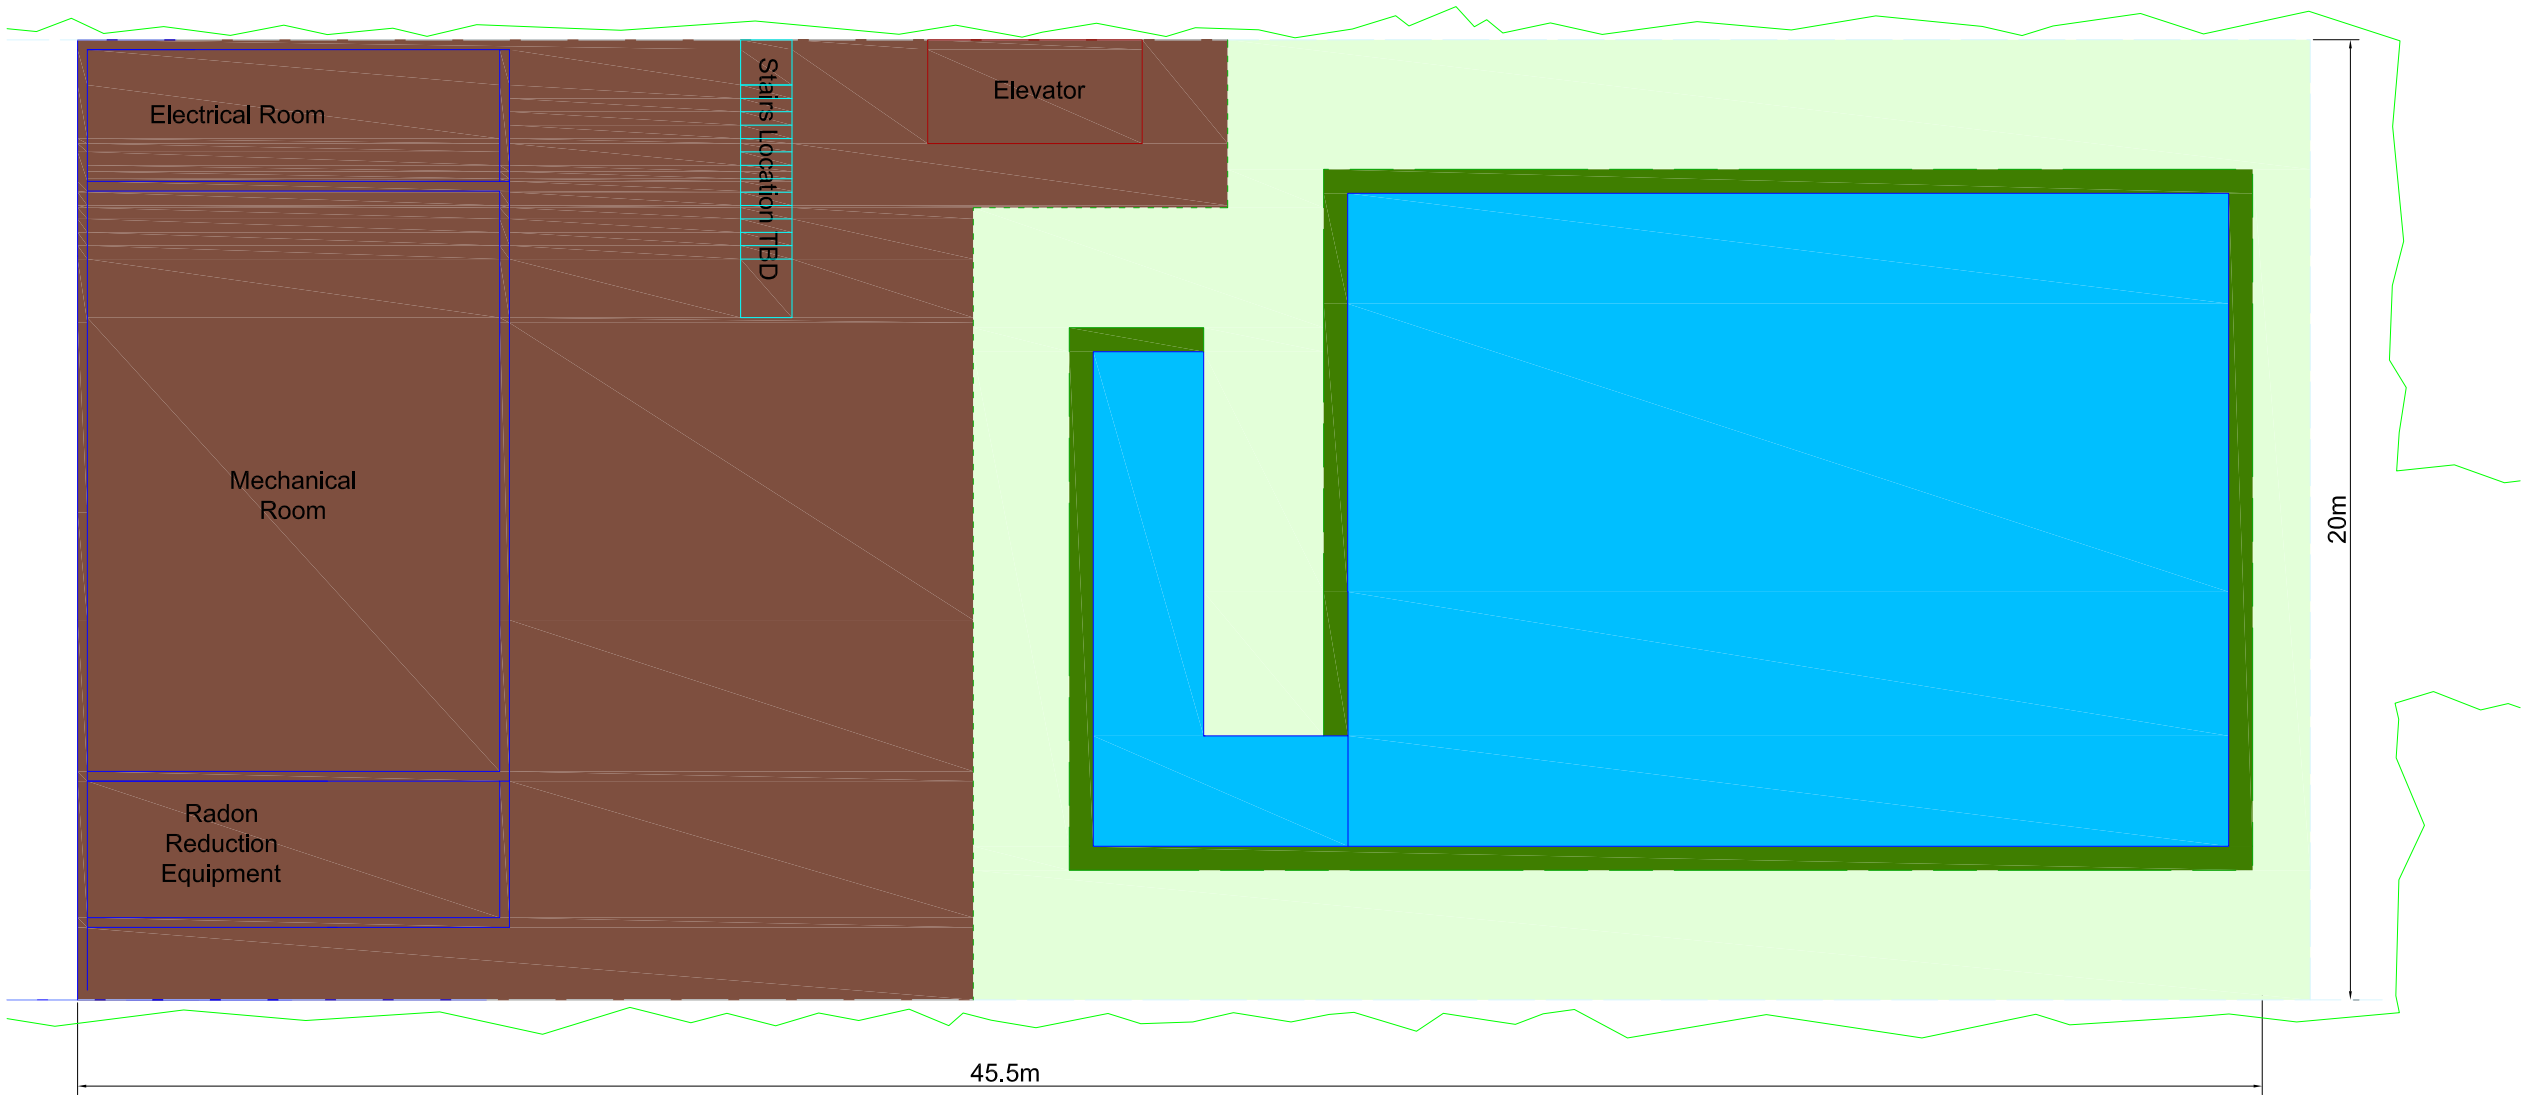

FAARM THIRD FLOOR PLAN

Signature _____
X _____
Name _____
X _____ X _____
Date _____ License # _____

PROJECT: _____

UNIVERSITY OF MN

FAARM

CITY, STATE

REVISED:		
NO.	DATE	REMARK
#	#	#
#	#	#
COMM. NO.: CNA0902
DATE: NOVEMBER 19, 2009
DRAWN: XXX
CHECKED: XXX

DRAWING TITLE: _____

DRAWING NUMBER: _____

####

Signature _____
X _____
Name _____
X _____
Date _____ License # _____

PROJECT: _____

UNIVERSITY OF MN

FAARM

CITY, STATE

REVISED: _____

NO.	DATE	REMARK
#	#	#
#	#	#
COMM. NO.: CNA0902

DATE: NOVEMBER 19, 2009

DRAWN: XXX

CHECKED: XXX

DRAWING TITLE: _____

DRAWING NUMBER: _____

####

- Classified Space

Unclassified Space

Transition Space


Water Shield

Veto Shield
- Tank

Photomultiplier Tubes

Monorail

Experiment Equipment

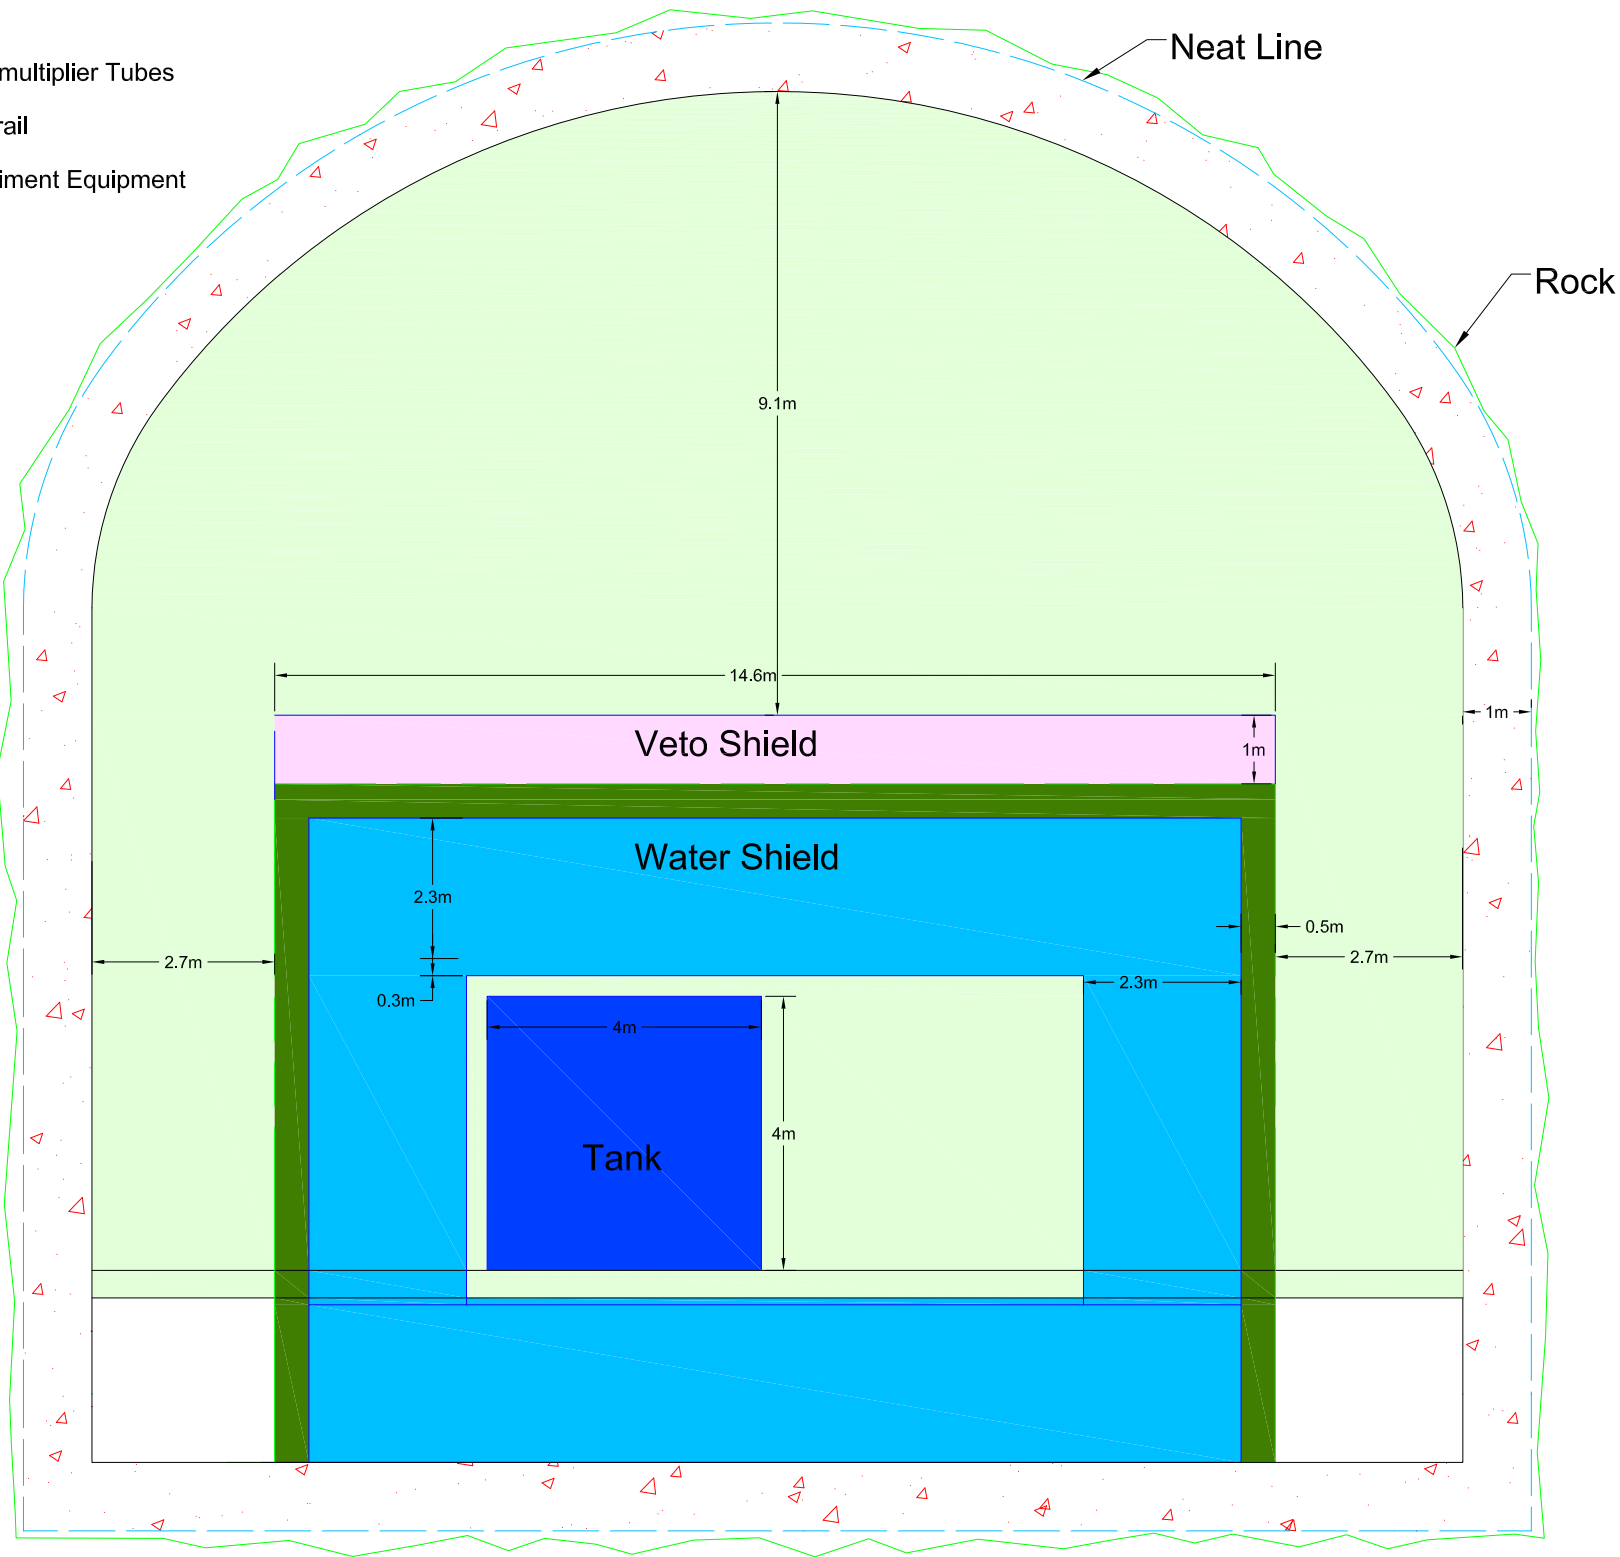

X
XXX

FAARM SECTION AA

0

- Classified Space

Unclassified Space

Transition Space


Water Shield

Veto Shield
- Tank

Photomultiplier Tubes

Monorail

Experiment Equipment

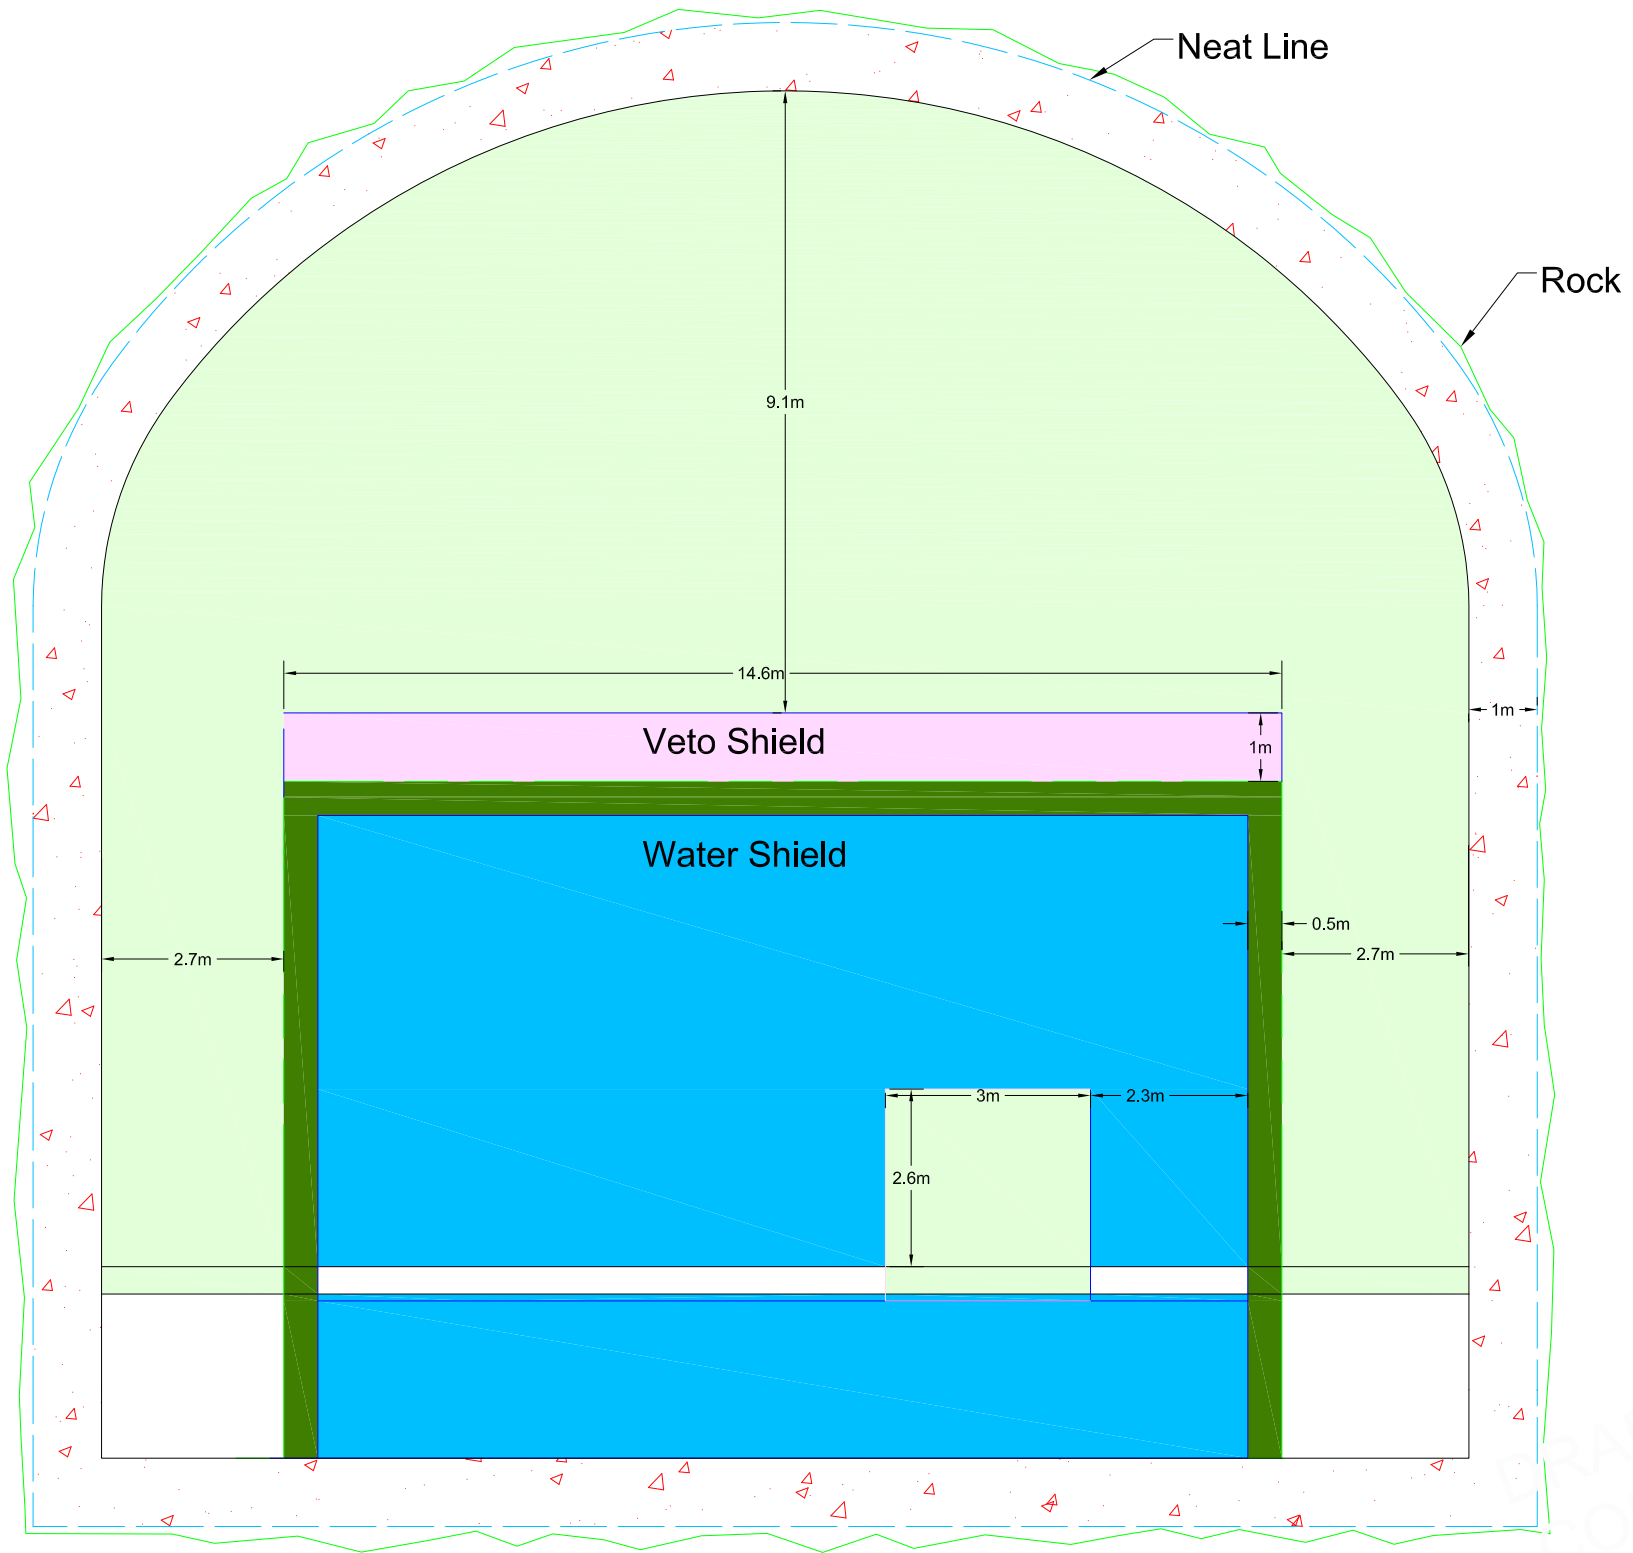

FAARM SECTION BB

Signature _____
X _____
Name _____
X _____
Date _____ License # _____

PROJECT: _____

UNIVERSITY OF MN
FAARM

CITY, STATE

REVISED		
NO.	DATE	REMARK
#	#	#
#	#	#
#	#	#
#	#	#
#	#	#
#	#	#
#	#	#

COMM. NO.: CNA0902
DATE: NOVEMBER 19, 2009
DRAWN: XXX
CHECKED: XXX

DRAWING TITLE: _____

#####

DRAWING NUMBER: _____

####

Signature _____
X _____
Name _____
X _____
Date _____ License # _____

PROJECT: _____

UNIVERSITY OF MN

FAARM

CITY, STATE

REVISED		
NO.	DATE	REMARK
#	#	#
#	#	#
#	#	#
#	#	#
#	#	#
#	#	#
#	#	#
#	#	#

COMM. NO.: CNA0902

DATE: NOVEMBER 19, 2009

DRAWN: XXX

CHECKED: XXX

DRAWING TITLE: _____

#####

DRAWING NUMBER: _____

####

- Classified Space

Unclassified Space

Transition Space


Water Shield

Veto Shield
- Tank

Photomultiplier Tubes

Monorail

Experiment Equipment

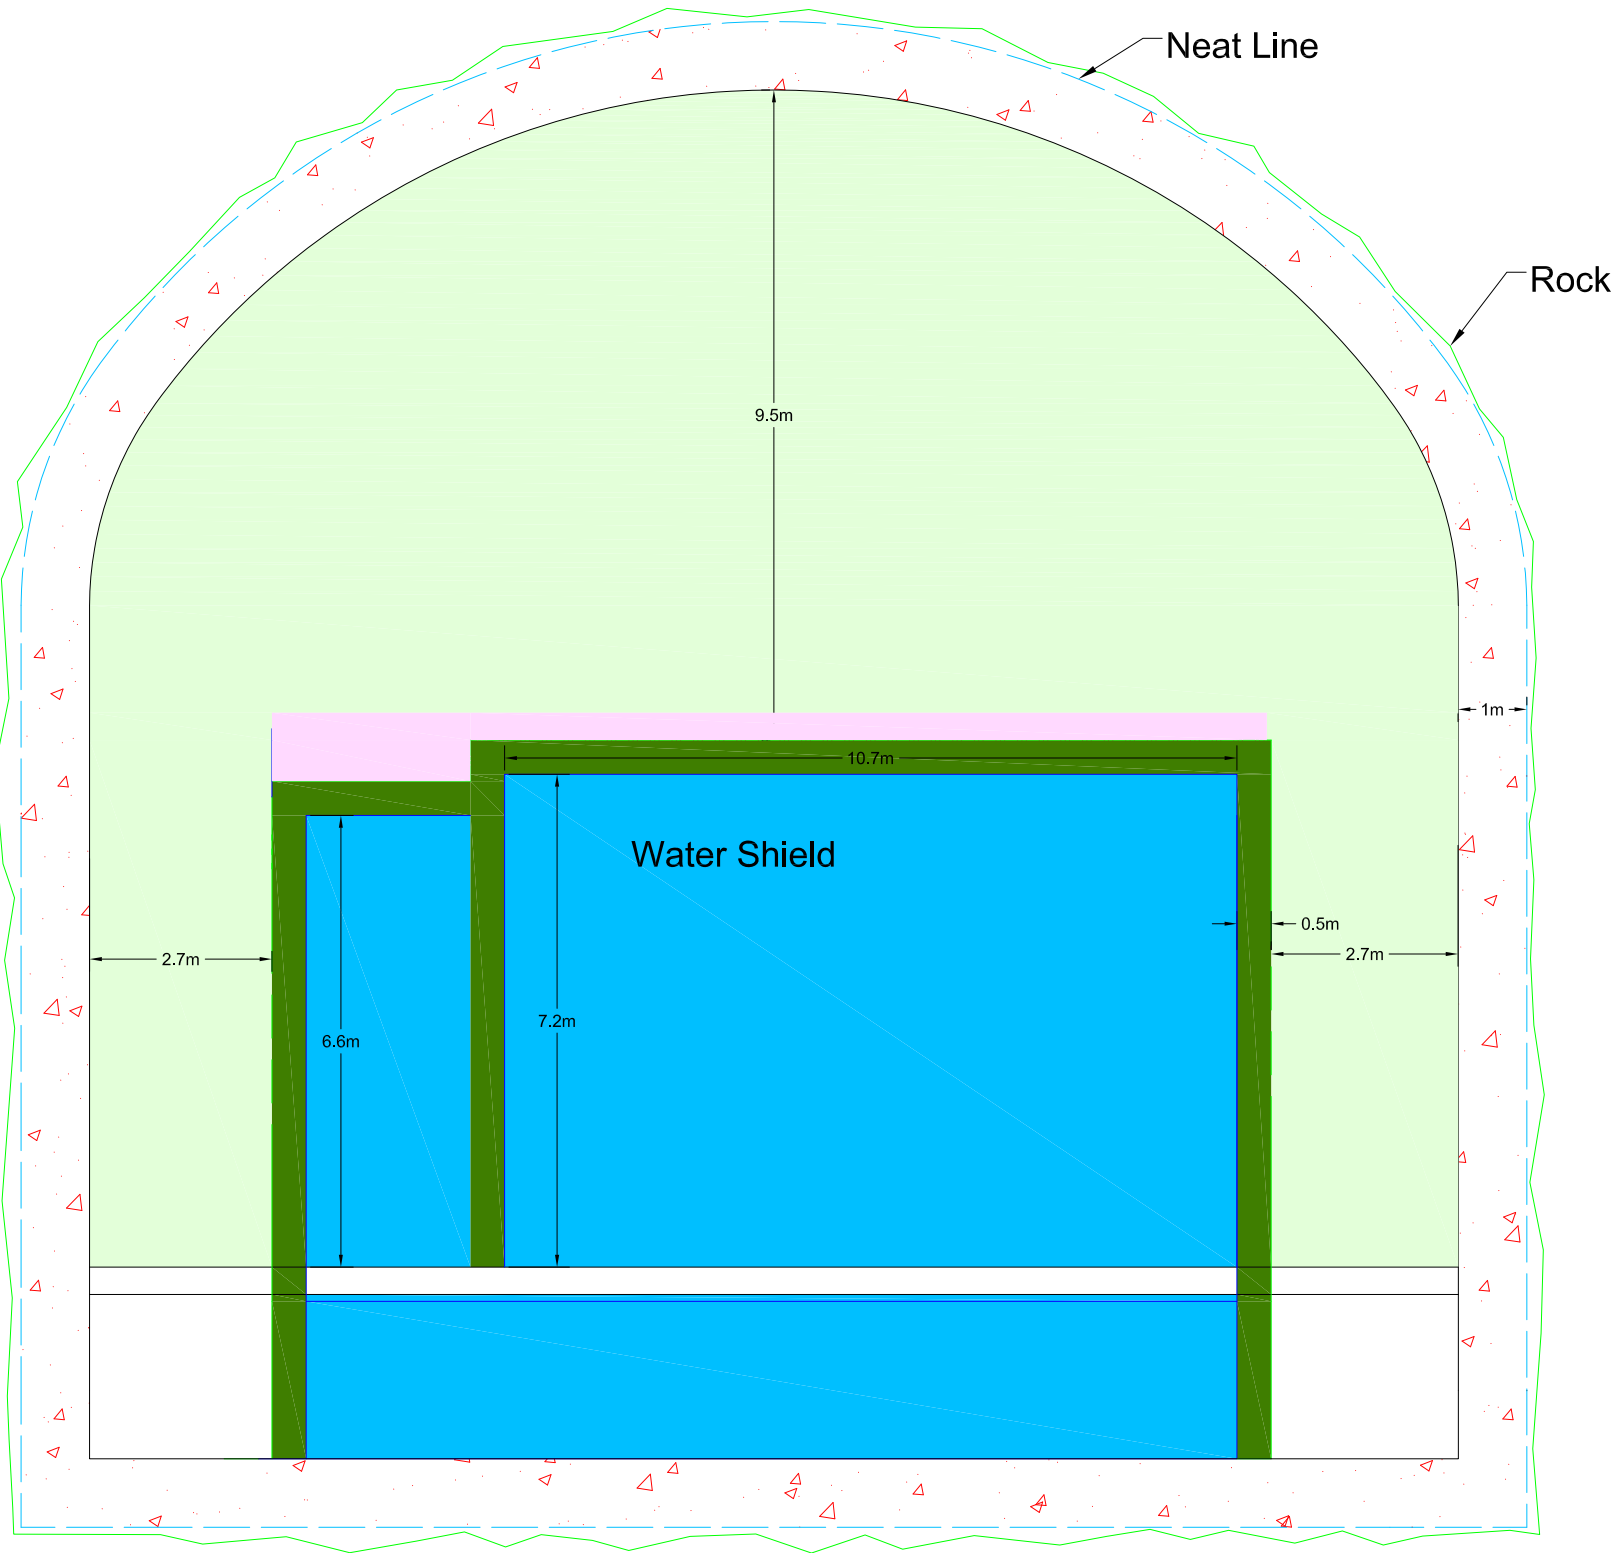

FAARM SECTION CC

