 



1
GA-01
MODULE ELEVATION




- Classified Space
- Unclassified Space
- Transition Space
- Water Shield
- Tank
- Photomultiplier Tubes and Plumbing
- Experiment Equipment
- Veto Shield

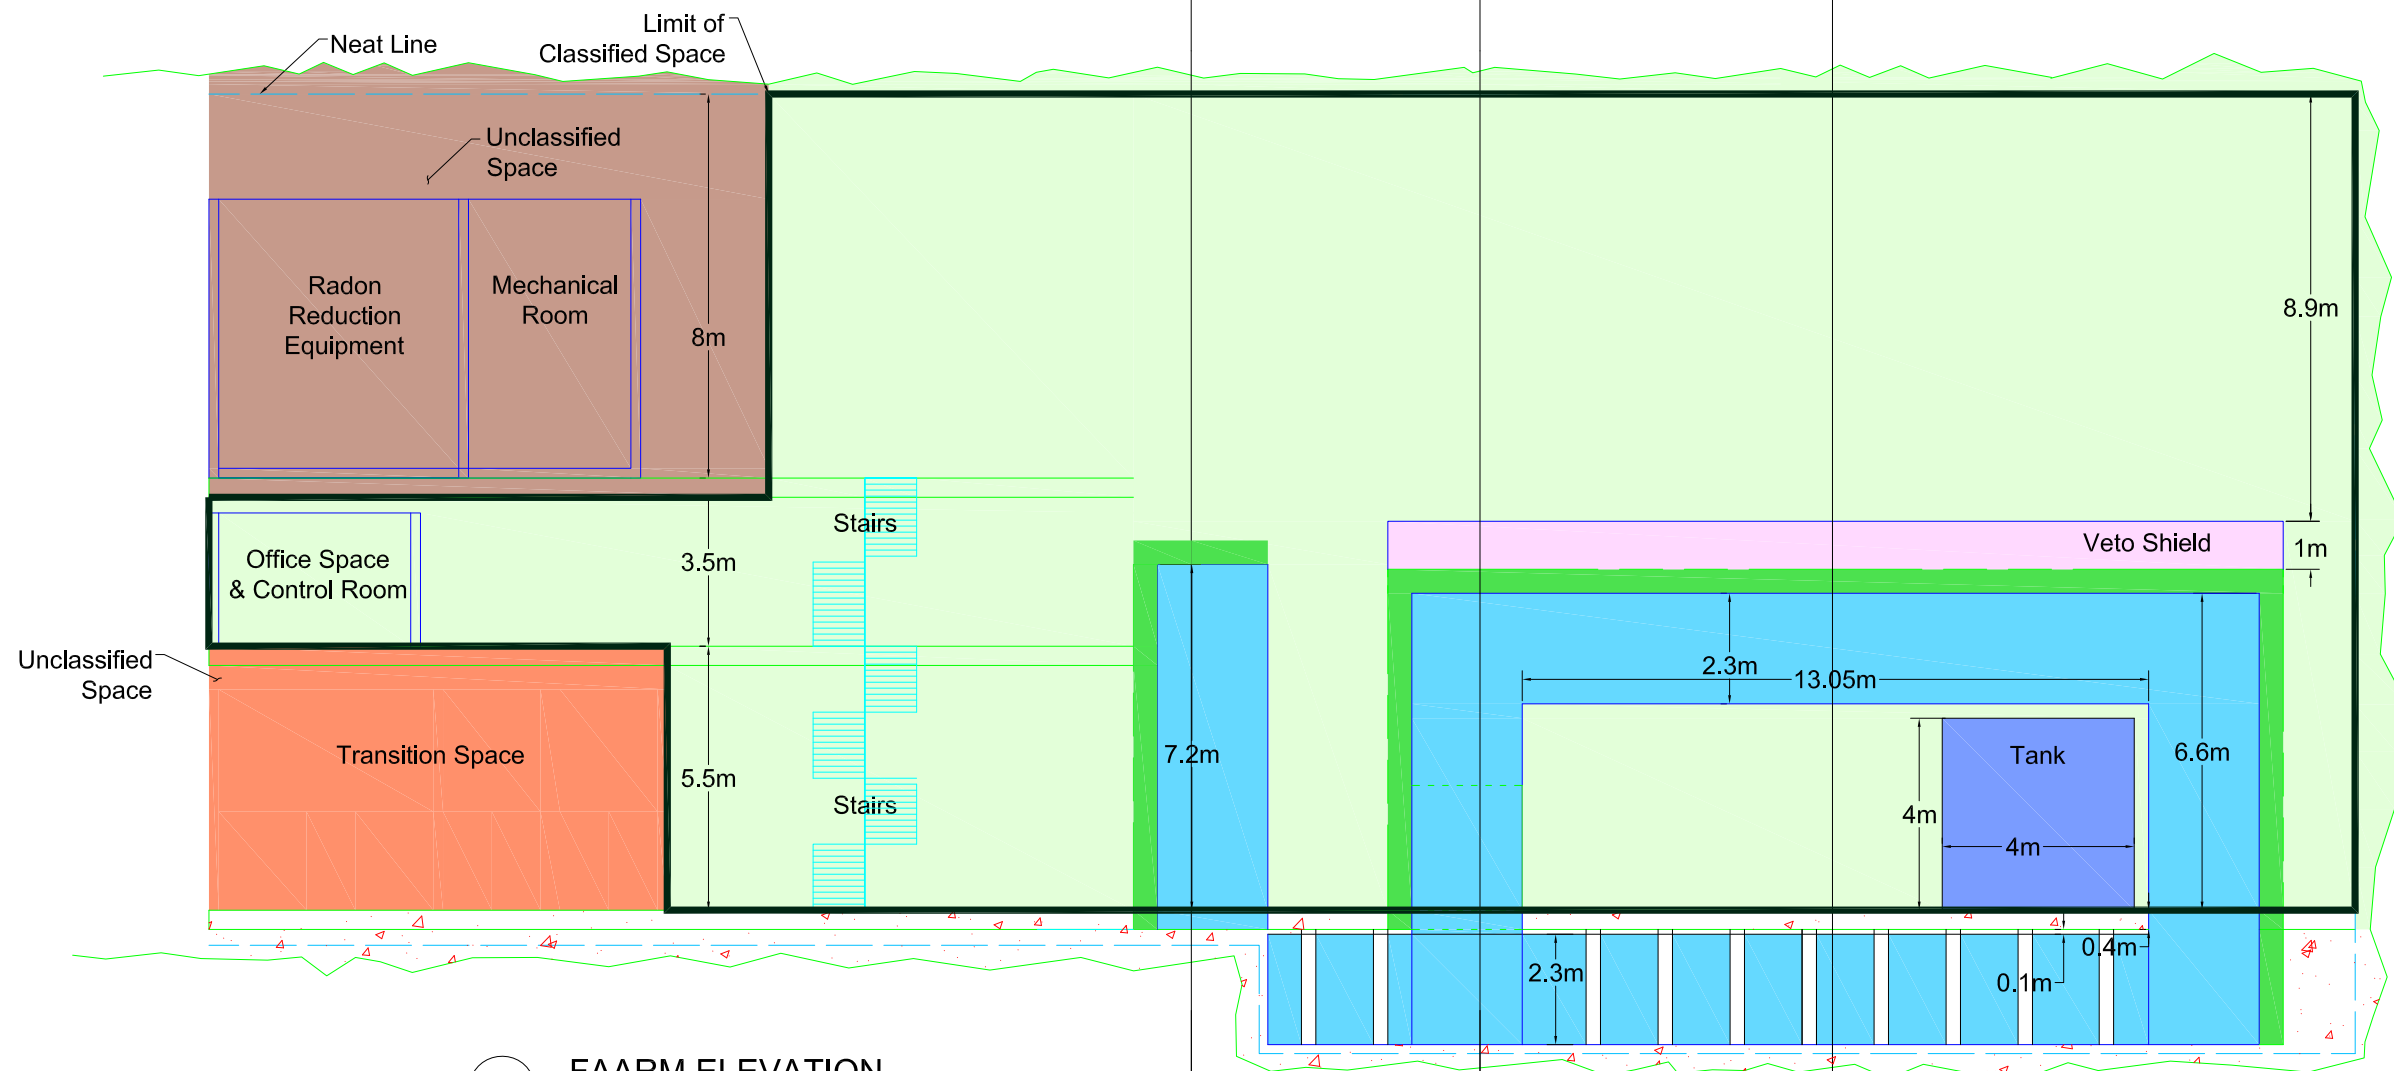

2
GA-01
FAARM ELEVATION



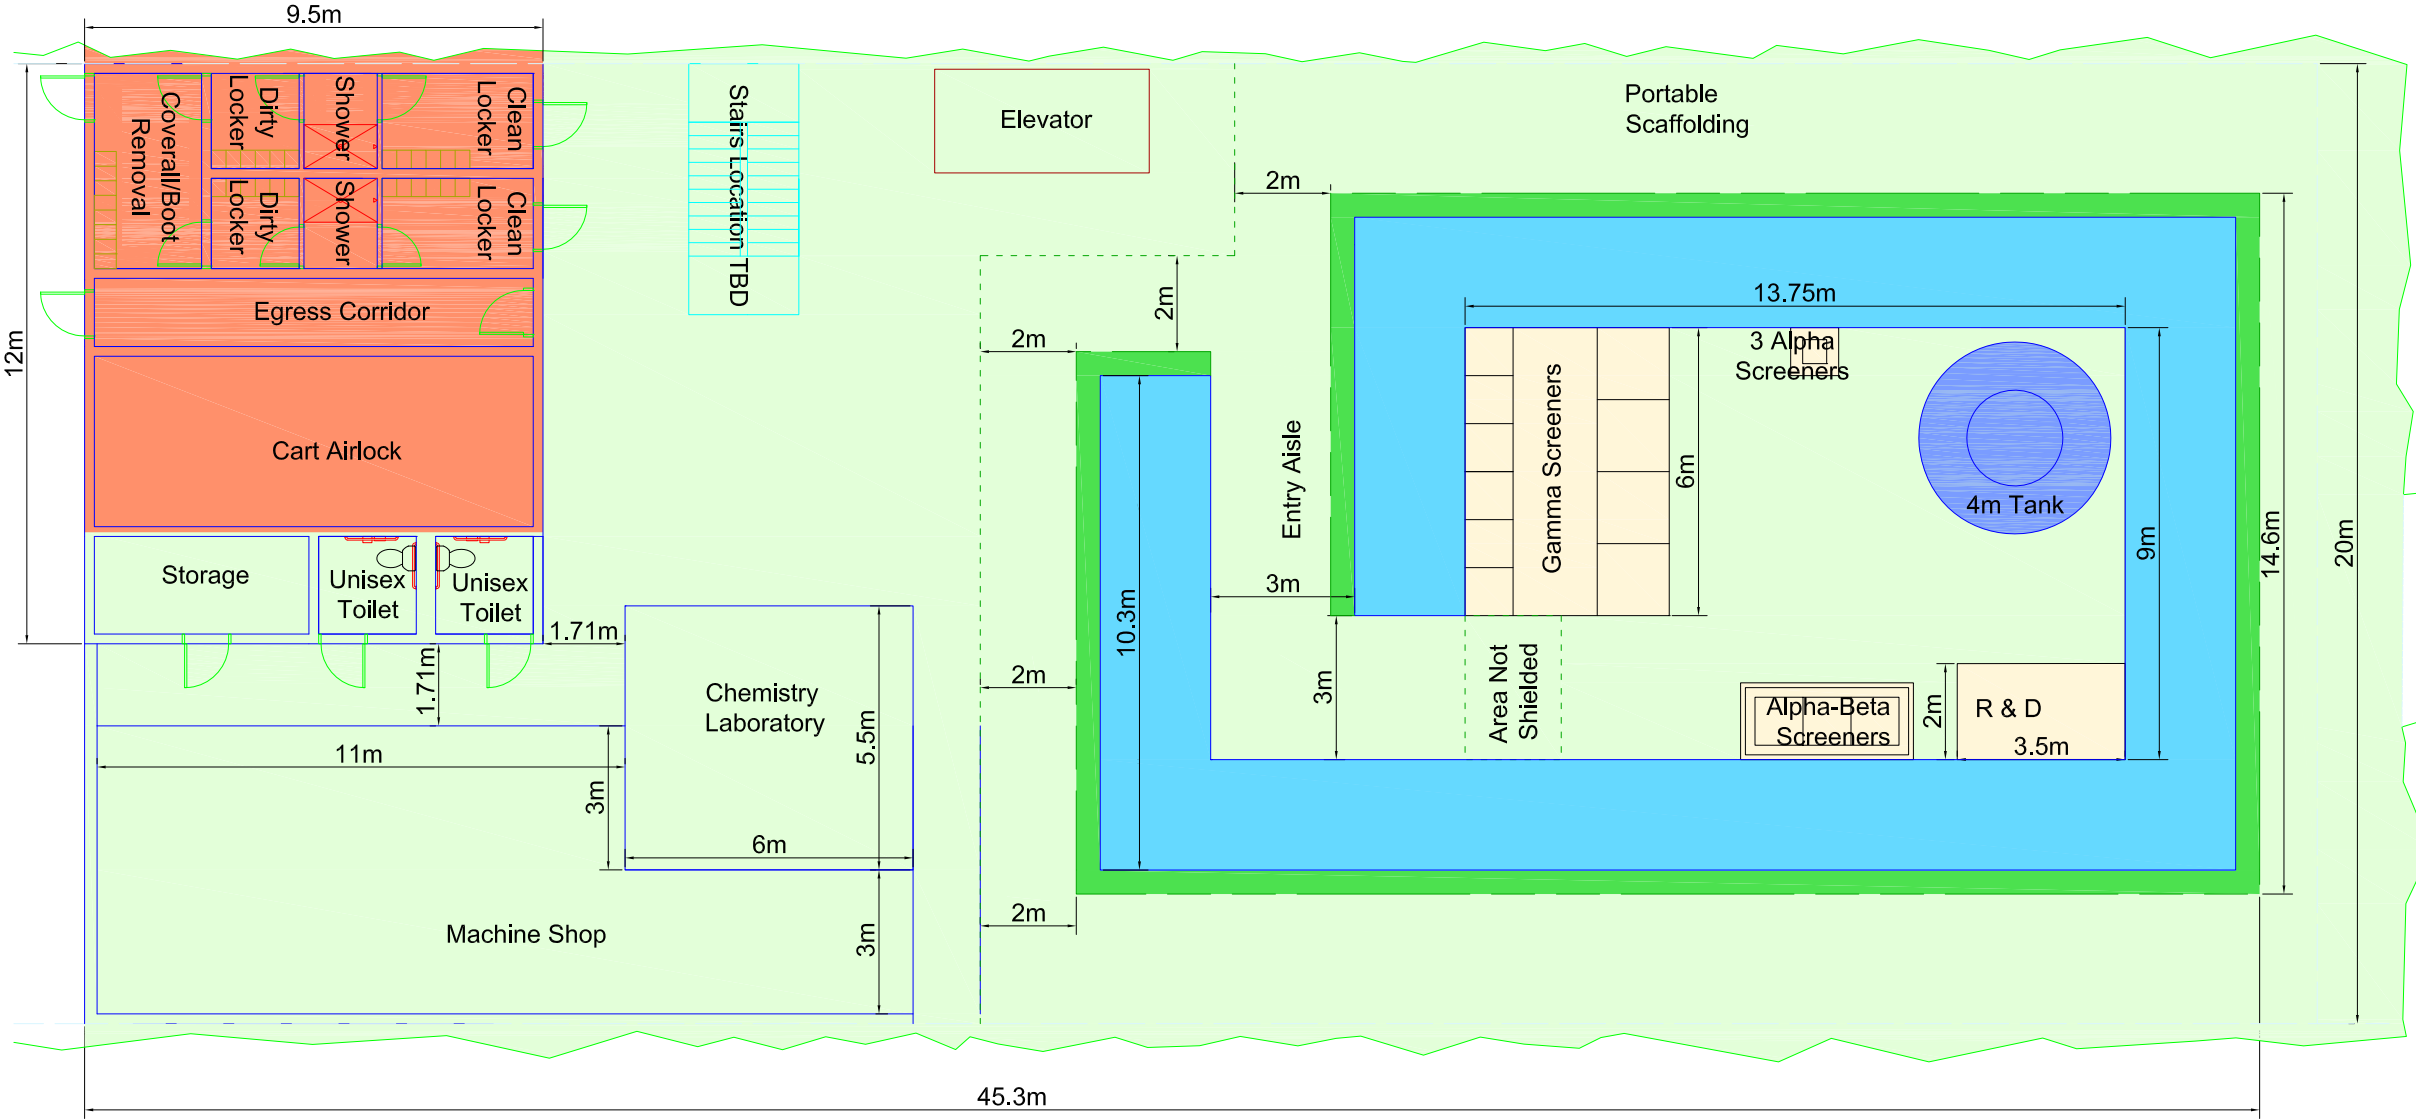

1
GA-02
FAARM FIRST FLOOR PLAN
0 2m 4m

DRAFT
COPY

Signature
X
Name
X
Date
X
License #

PROJECT:

UNIVERSITY OF MN

FAARM

CITY, STATE

REVISED:

NO.	DATE	REMARK
#	#	#
#	#	#
#	#	#
#	#	#
#	#	#
#	#	#
#	#	#

COMM. NO.2 CNA0902

DATE: NOVEMBER 19, 2009

DRAWN: XXX

CHECKED: XXX

DRAWING TITLE:

DRAWING NUMBER:

GA-02

- Classified Space

Unclassified Space


Transition Space

Water Shield
- Tank

Photomultiplier Tubes and Plumbing

Experiment Equipment

Veto Shield

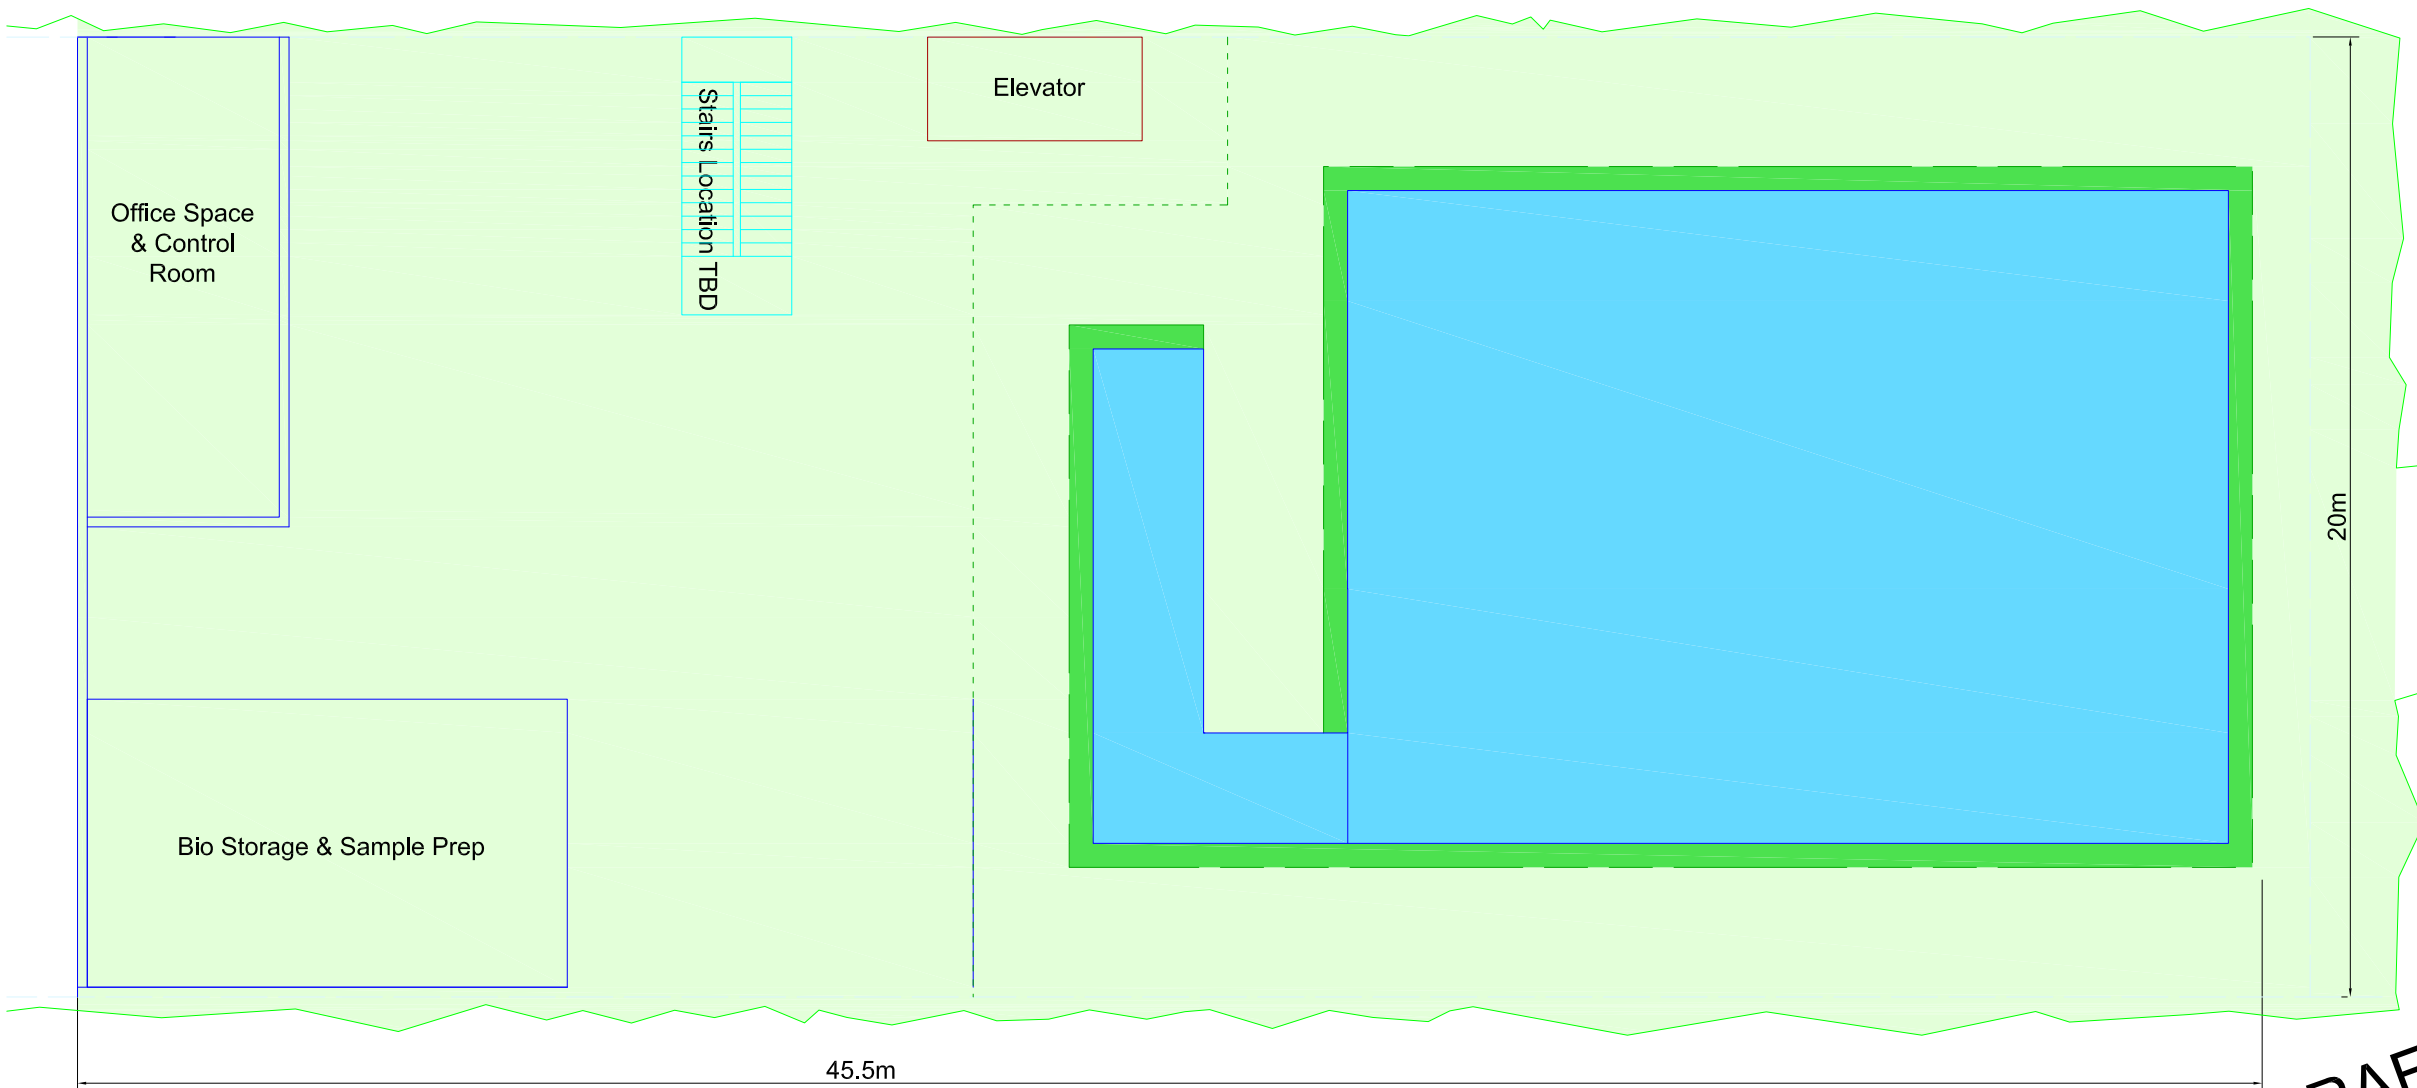

1
GA-03

02m4m

FAARM SECOND FLOOR PLAN

Signature

X

Name

X

Date

X

License #

PROJECT:

UNIVERSITY OF MN

FAARM

CITY, STATE

REVISED:

NO.	DATE	REMARK
#	#	#
#	#	#
NO. OR
DESCRIPTION

COMM. NO.2

CNA0902

DATE:

NOVEMBER 19, 2009

DRAWN:

XXX

CHECKED:

XXX

DRAWING TITLE:

DRAWING NUMBER:

GA-03

DRAFT
COPY

- Classified Space

Unclassified Space


Transition Space

Water Shield
- Tank

Photomultiplier Tubes and Plumbing

Experiment Equipment

Veto Shield

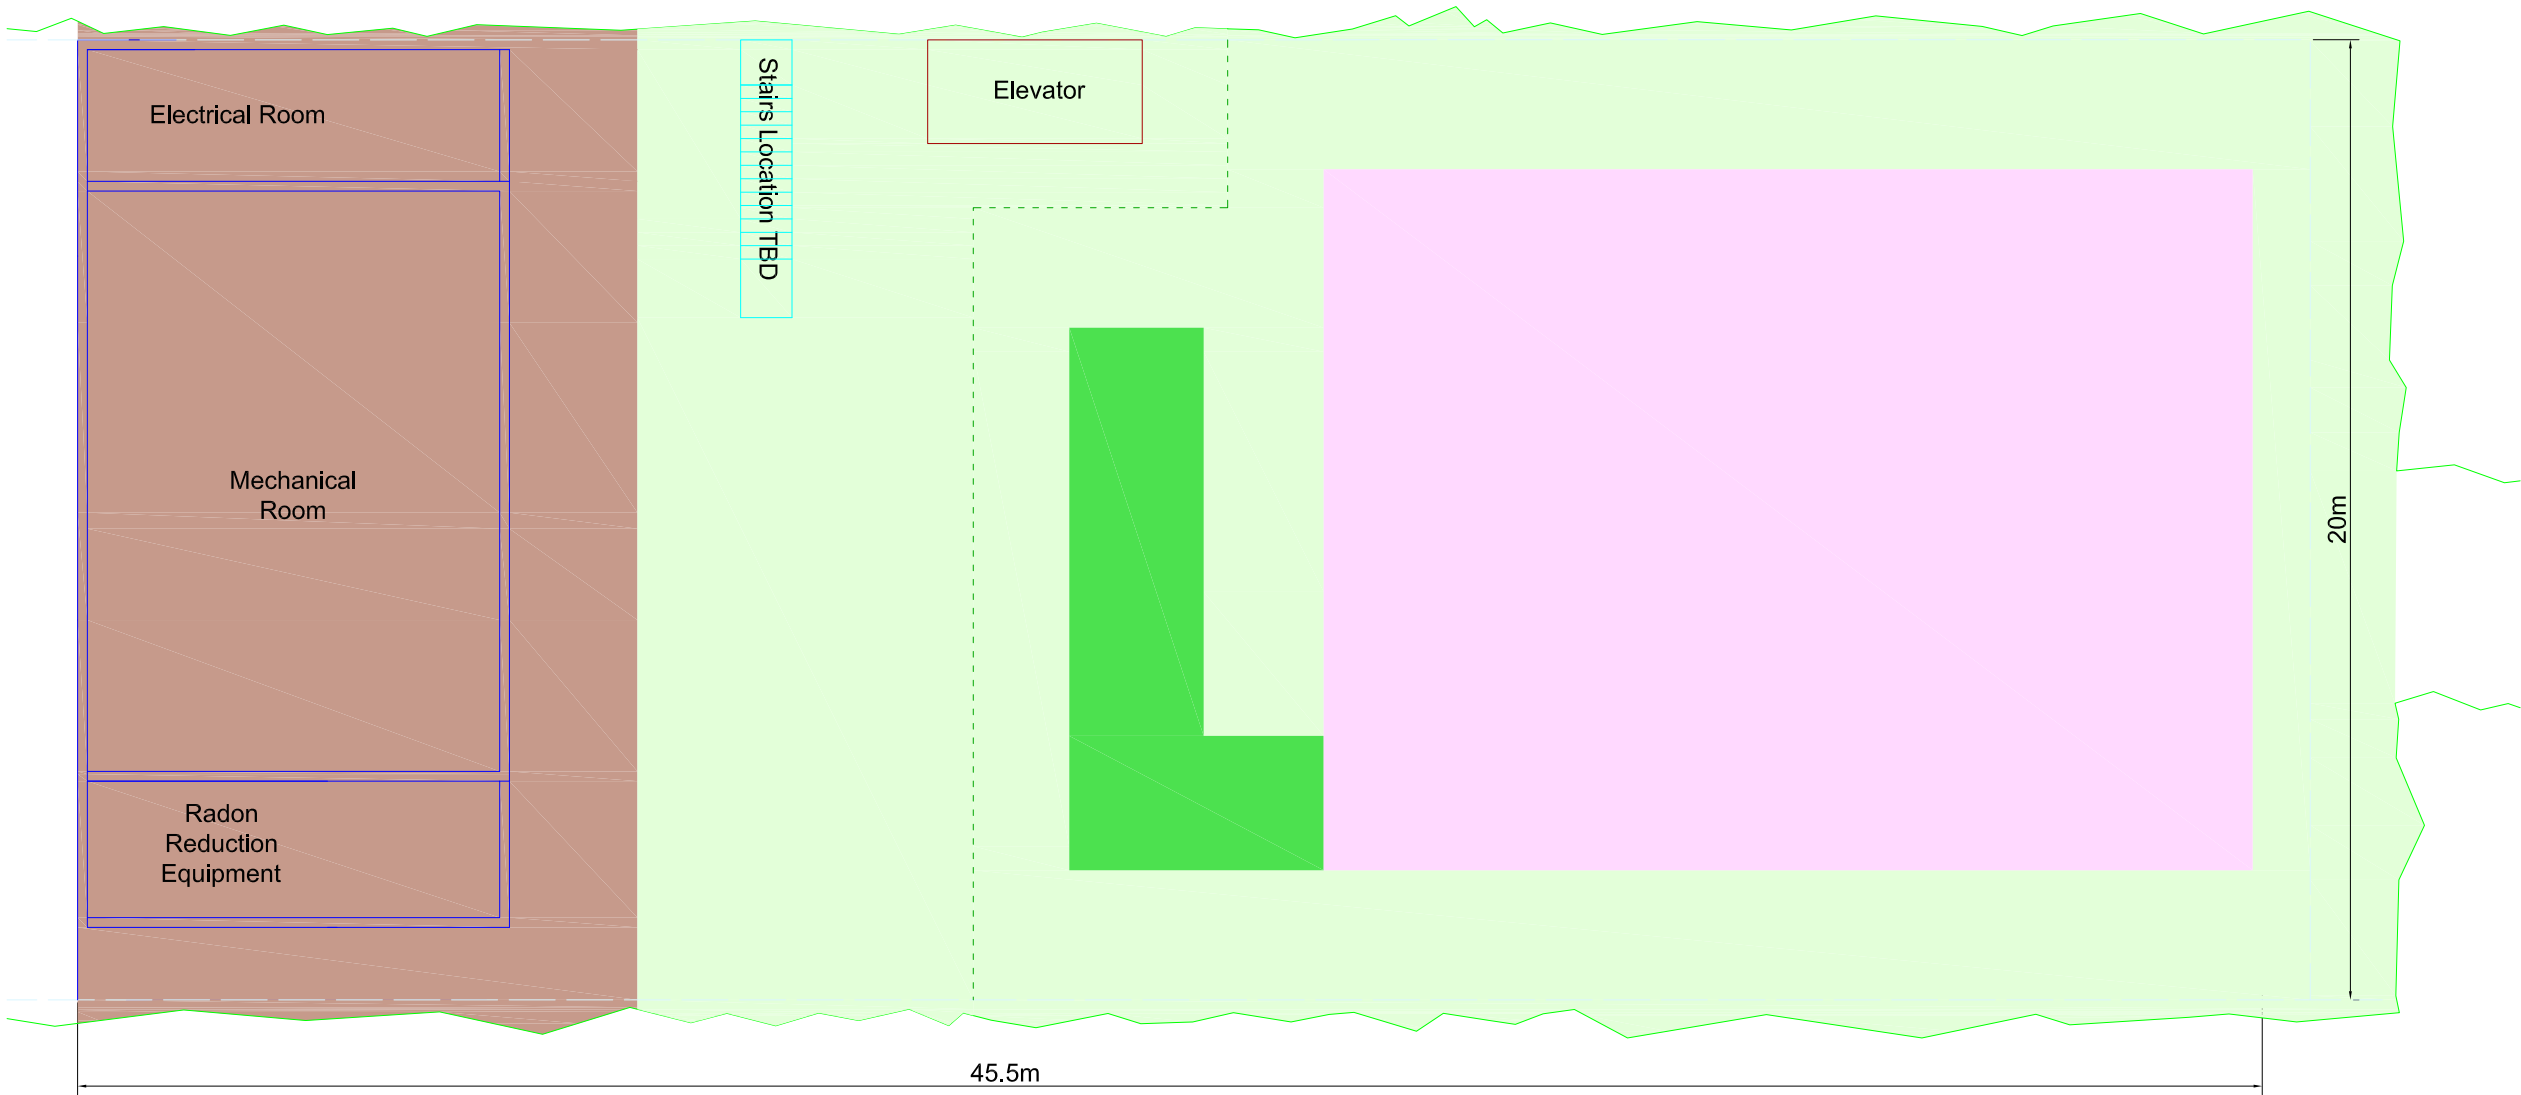

PROJECT: _____

UNIVERSITY OF MN
FAARM

CITY, STATE

REVISED:		
NO.	DATE	REMARK
#	#	#
#	#	#
#	#	#
#	#	#
#	#	#
#	#	#
#	#	#
#	#	#

COMM. NO.: CNA0902
DATE: NOVEMBER 19, 2009
DRAWN: XXX
CHECKED: XXX

DRAWING TITLE: _____

DRAWING NUMBER: _____

GA-04

1
GA-04
FAARM THIRD FLOOR PLAN
0 2m 4m

- Classified Space

Unclassified Space


Transition Space

Water Shield
- Tank

Photomultiplier Tubes and Plumbing

Experiment Equipment

Veto Shield

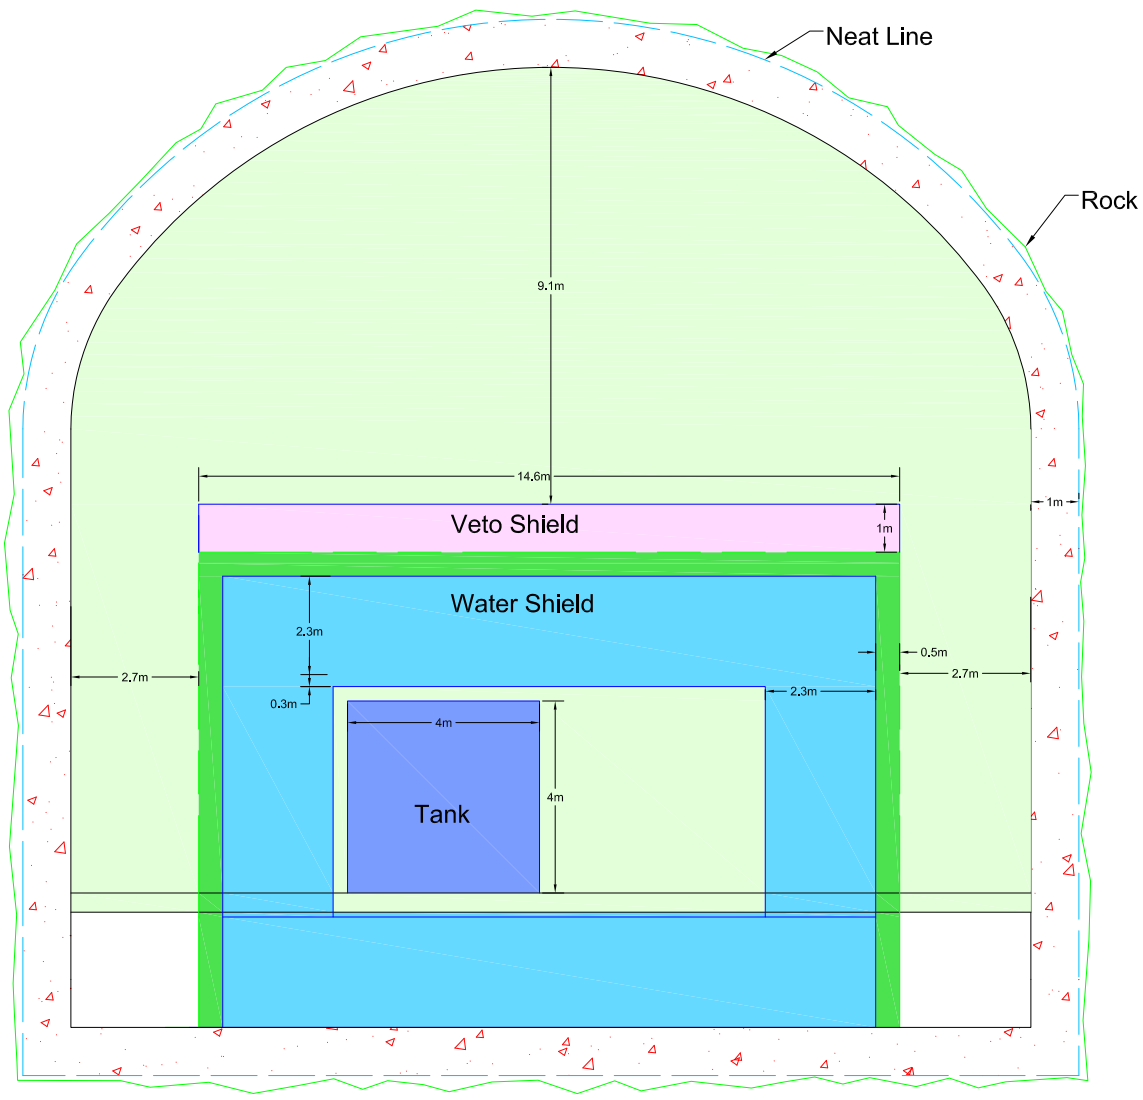

1
GA-05

Experiment Room Section



DRAFT
COPY

Signature
X
Name
X
Date
X
License #

PROJECT

UNIVERSITY OF MN

FAARM

CITY, STATE

REVISED		
NO.	DATE	REMARK
#	#	#
#	#	#
#	#	#
#	#	#
#	#	#
#	#	#
#	#	#
#	#	#

COMM. NO.: CNA0902
DATE: NOVEMBER 19, 2009
DRAWN: XXX
CHECKED: XXX

DRAWING TITLE:

#####

DRAWING NUMBER:

GA-05

- Classified Space

Unclassified Space


Transition Space

Water Shield
- Tank

Photomultiplier Tubes and Plumbing

Experiment Equipment

Veto Shield

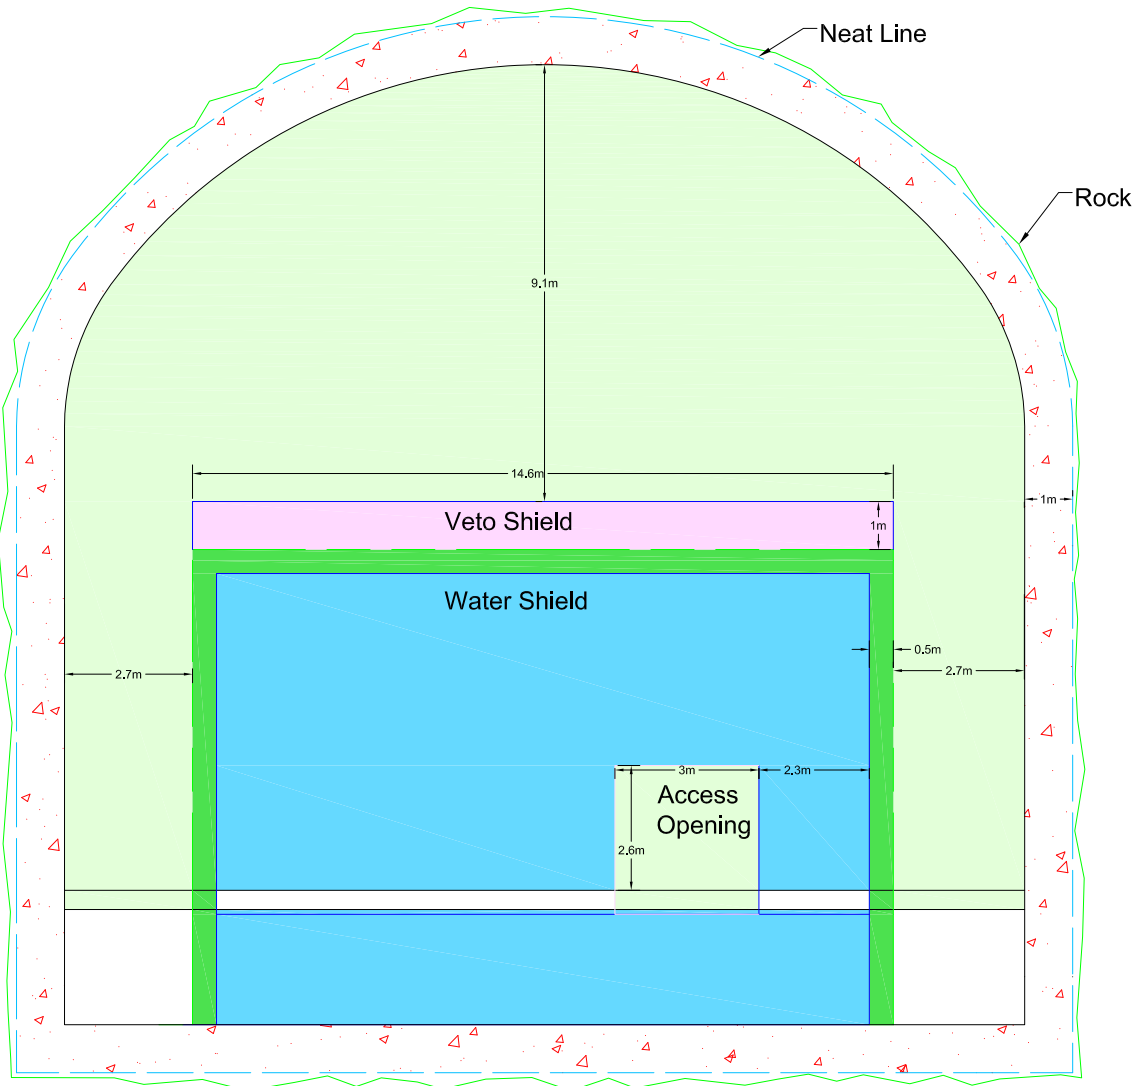

1
GA-06

Water Shield Section



DRAFT
COPY

Signature
X
Name
X
Date
X
License #

PROJECT

UNIVERSITY OF MN
FAARM

CITY, STATE

REVISED		
NO.	DATE	REMARK
#	#	#
#	#	#
#	#	#
#	#	#
#	#	#
#	#	#
#	#	#
#	#	#

COMM. NO.: CNA0902
DATE: NOVEMBER 19, 2009
DRAWN: XXX
CHECKED: XXX

DRAWING TITLE

#####

DRAWING NUMBER

GA-06

- Classified Space

Unclassified Space


Transition Space

Water Shield
- Tank

Photomultiplier Tubes and Plumbing

Experiment Equipment

Veto Shield

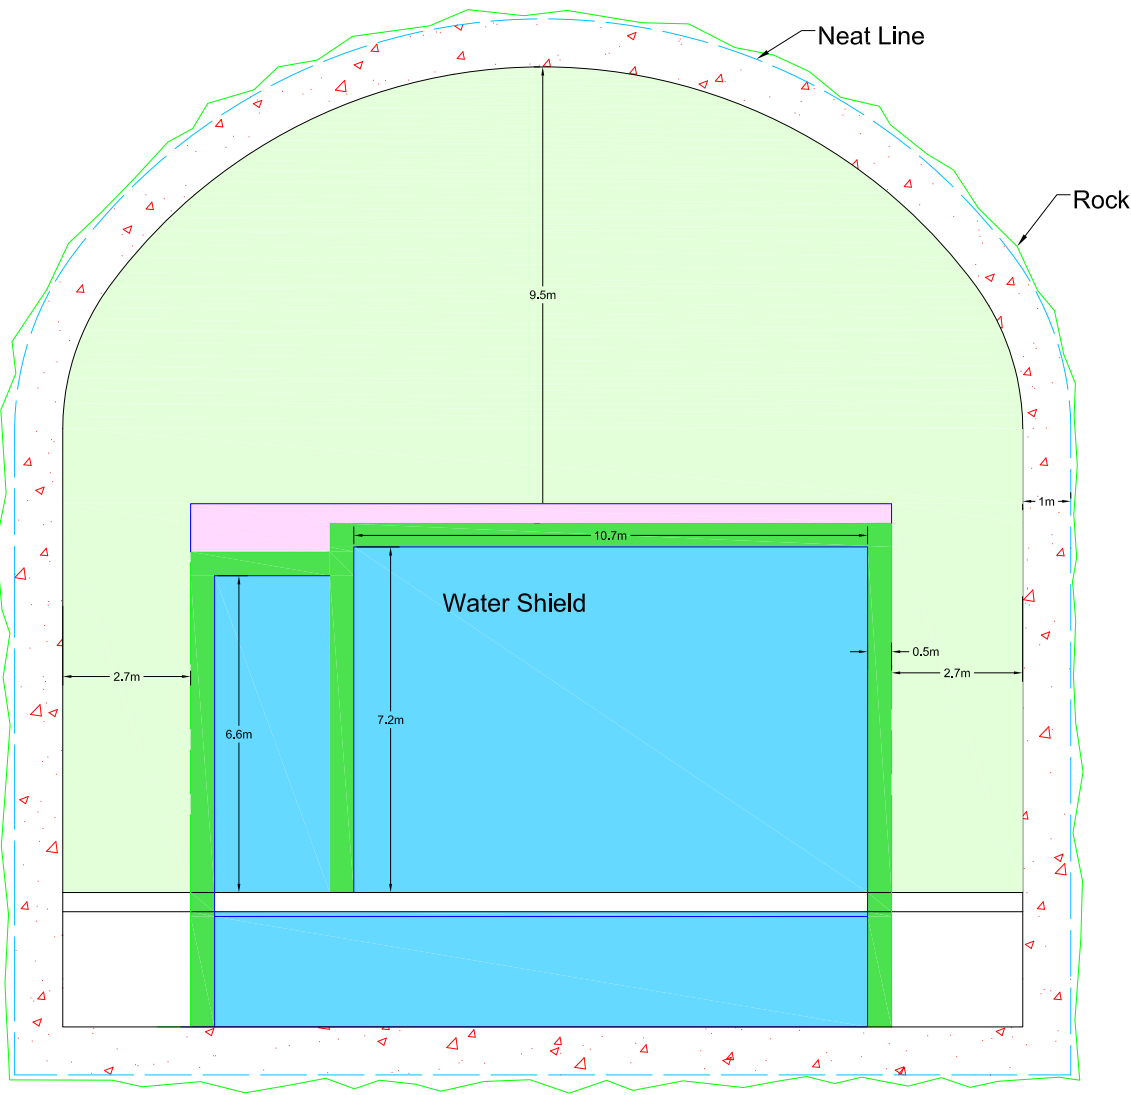

1
GA-07

Free-Standing Water Shield Section



DRAFT
COPY

Signature

X

Name

X

Date

X

License #

PROJECT

UNIVERSITY OF MN

FAARM

CITY, STATE

REVISED

NO.	DATE	REMARK
#	#	#
#	#	#
COMM. NO.: CNA0902

DATE: NOVEMBER 19, 2009

DRAWN: XXX

CHECKED: XXX

DRAWING TITLE:

#####

DRAWING NUMBER:

GA-07