


1 MODULE ELEVATION
GA-01 0 8m 16m

- Classified Space
- Unclassified Space
- Transition Space
- Water Shield
- Tank
- Photomultiplier Tubes and Plumbing
- Experiment Equipment
- Veto Shield

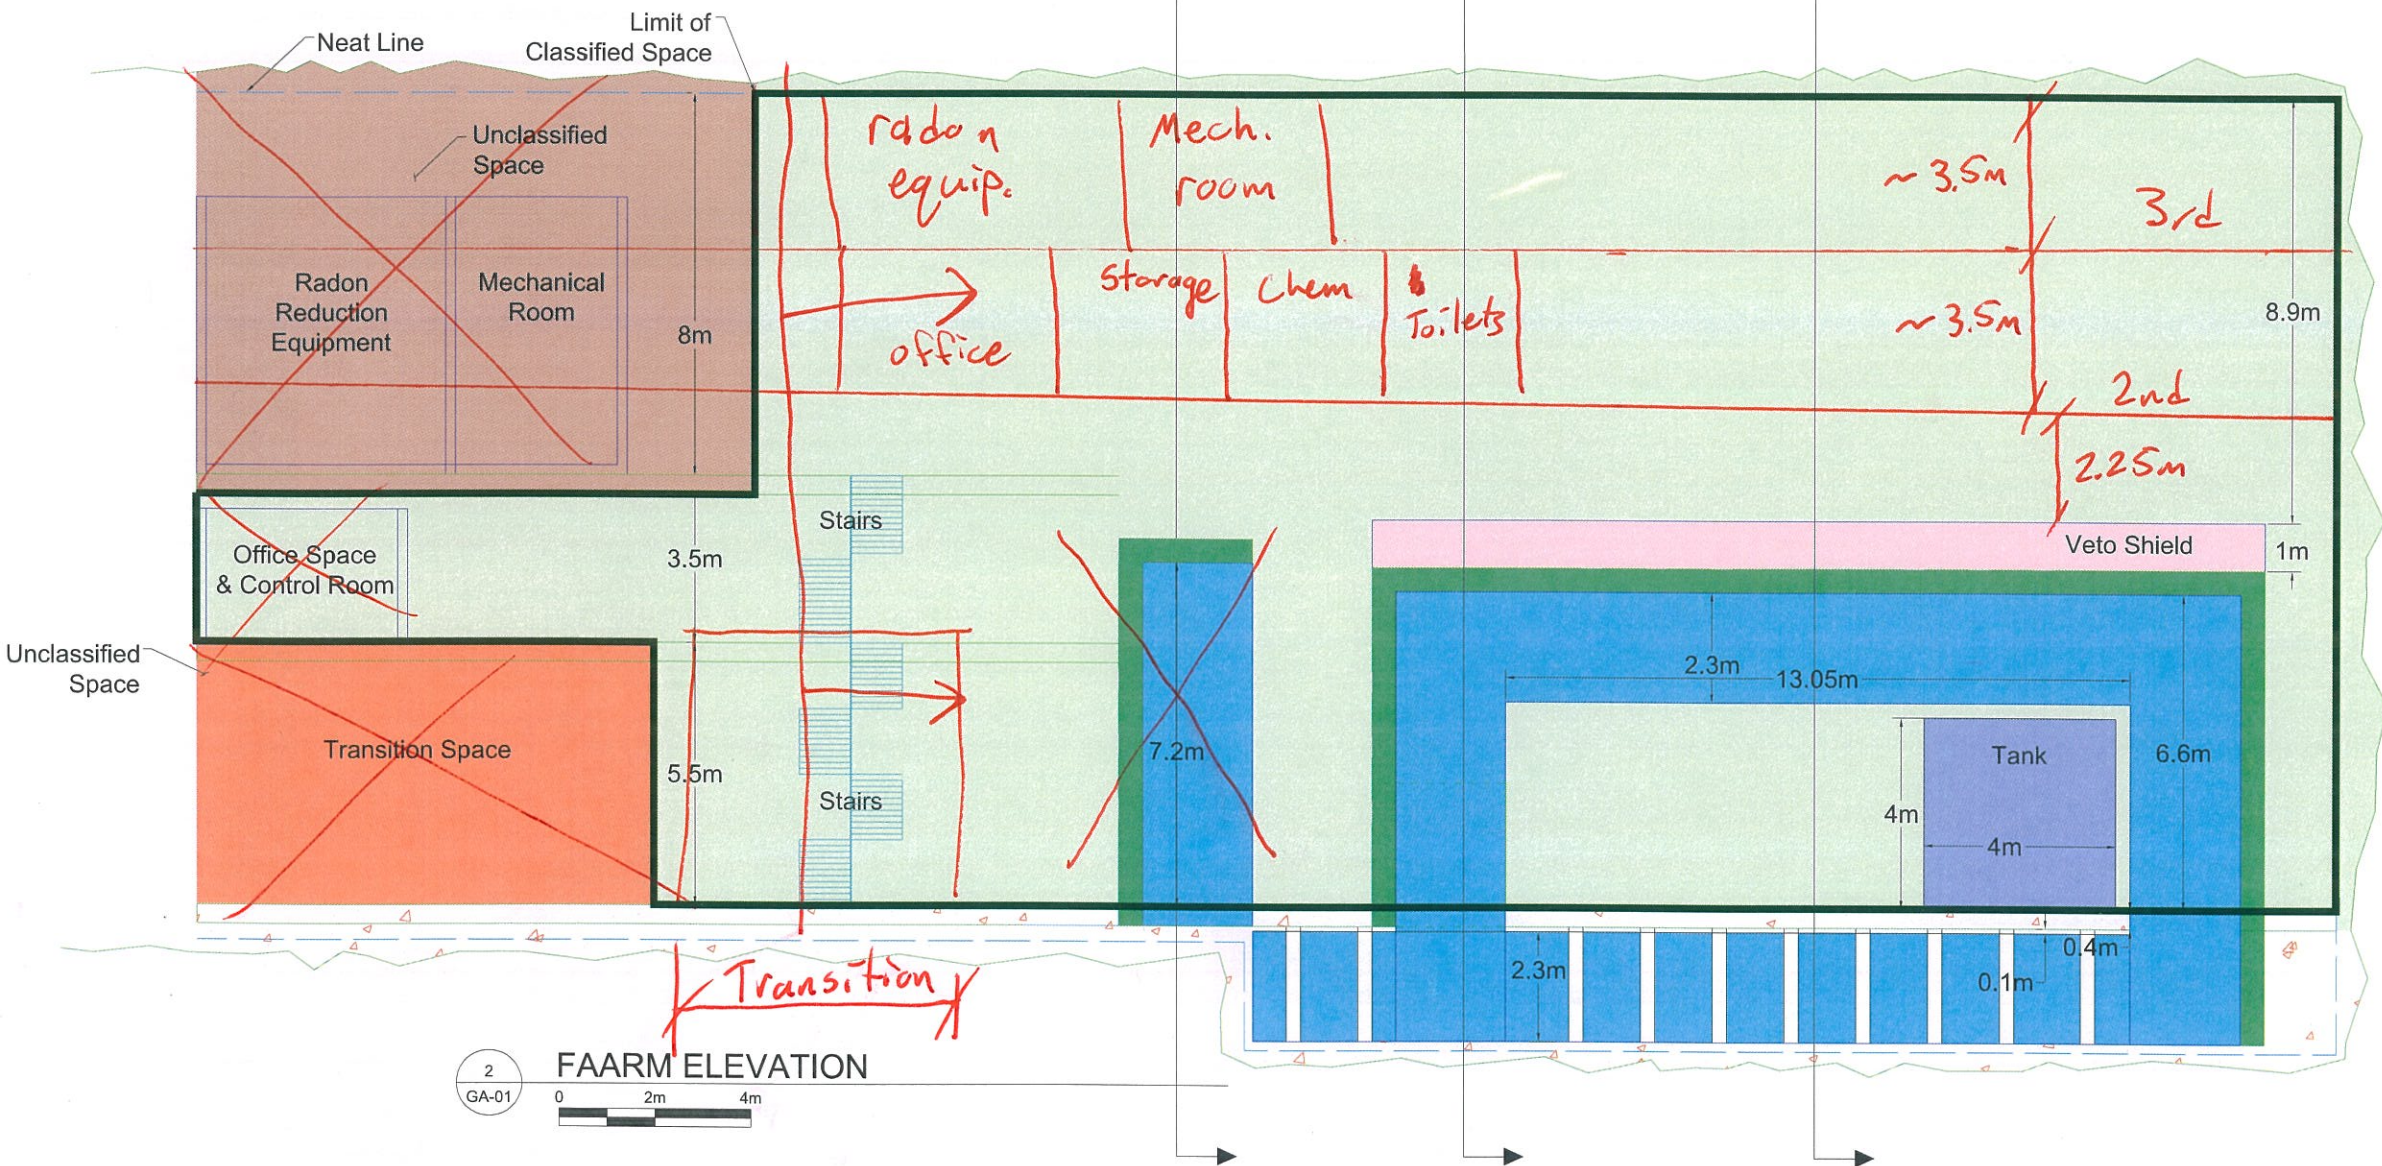

2 FAARM ELEVATION
GA-01 0 2m 4m

DRAFT COPY

Signature
X
Name
X
Date License #

PROJECT:

UNIVERSITY OF MN
FAARM

CITY, STATE

REVISED	NO.	DATE	REMARK
#	#	#	#
#	#	#	#
#	#	#	#
#	#	#	#
#	#	#	#
#	#	#	#

COMM. NO.: CNA0902
DATE: NOVEMBER 19, 2009
DRAWN: XXX
CHECKED: XXX


DRAWING TITLE:

#####

DRAWING NUMBER:

GA-01

- Classified Space
- Unclassified Space
- Transition Space
- Water Shield
- Tank
- Photomultiplier Tubes and Plumbing
- Experiment Equipment
- Veto Shield

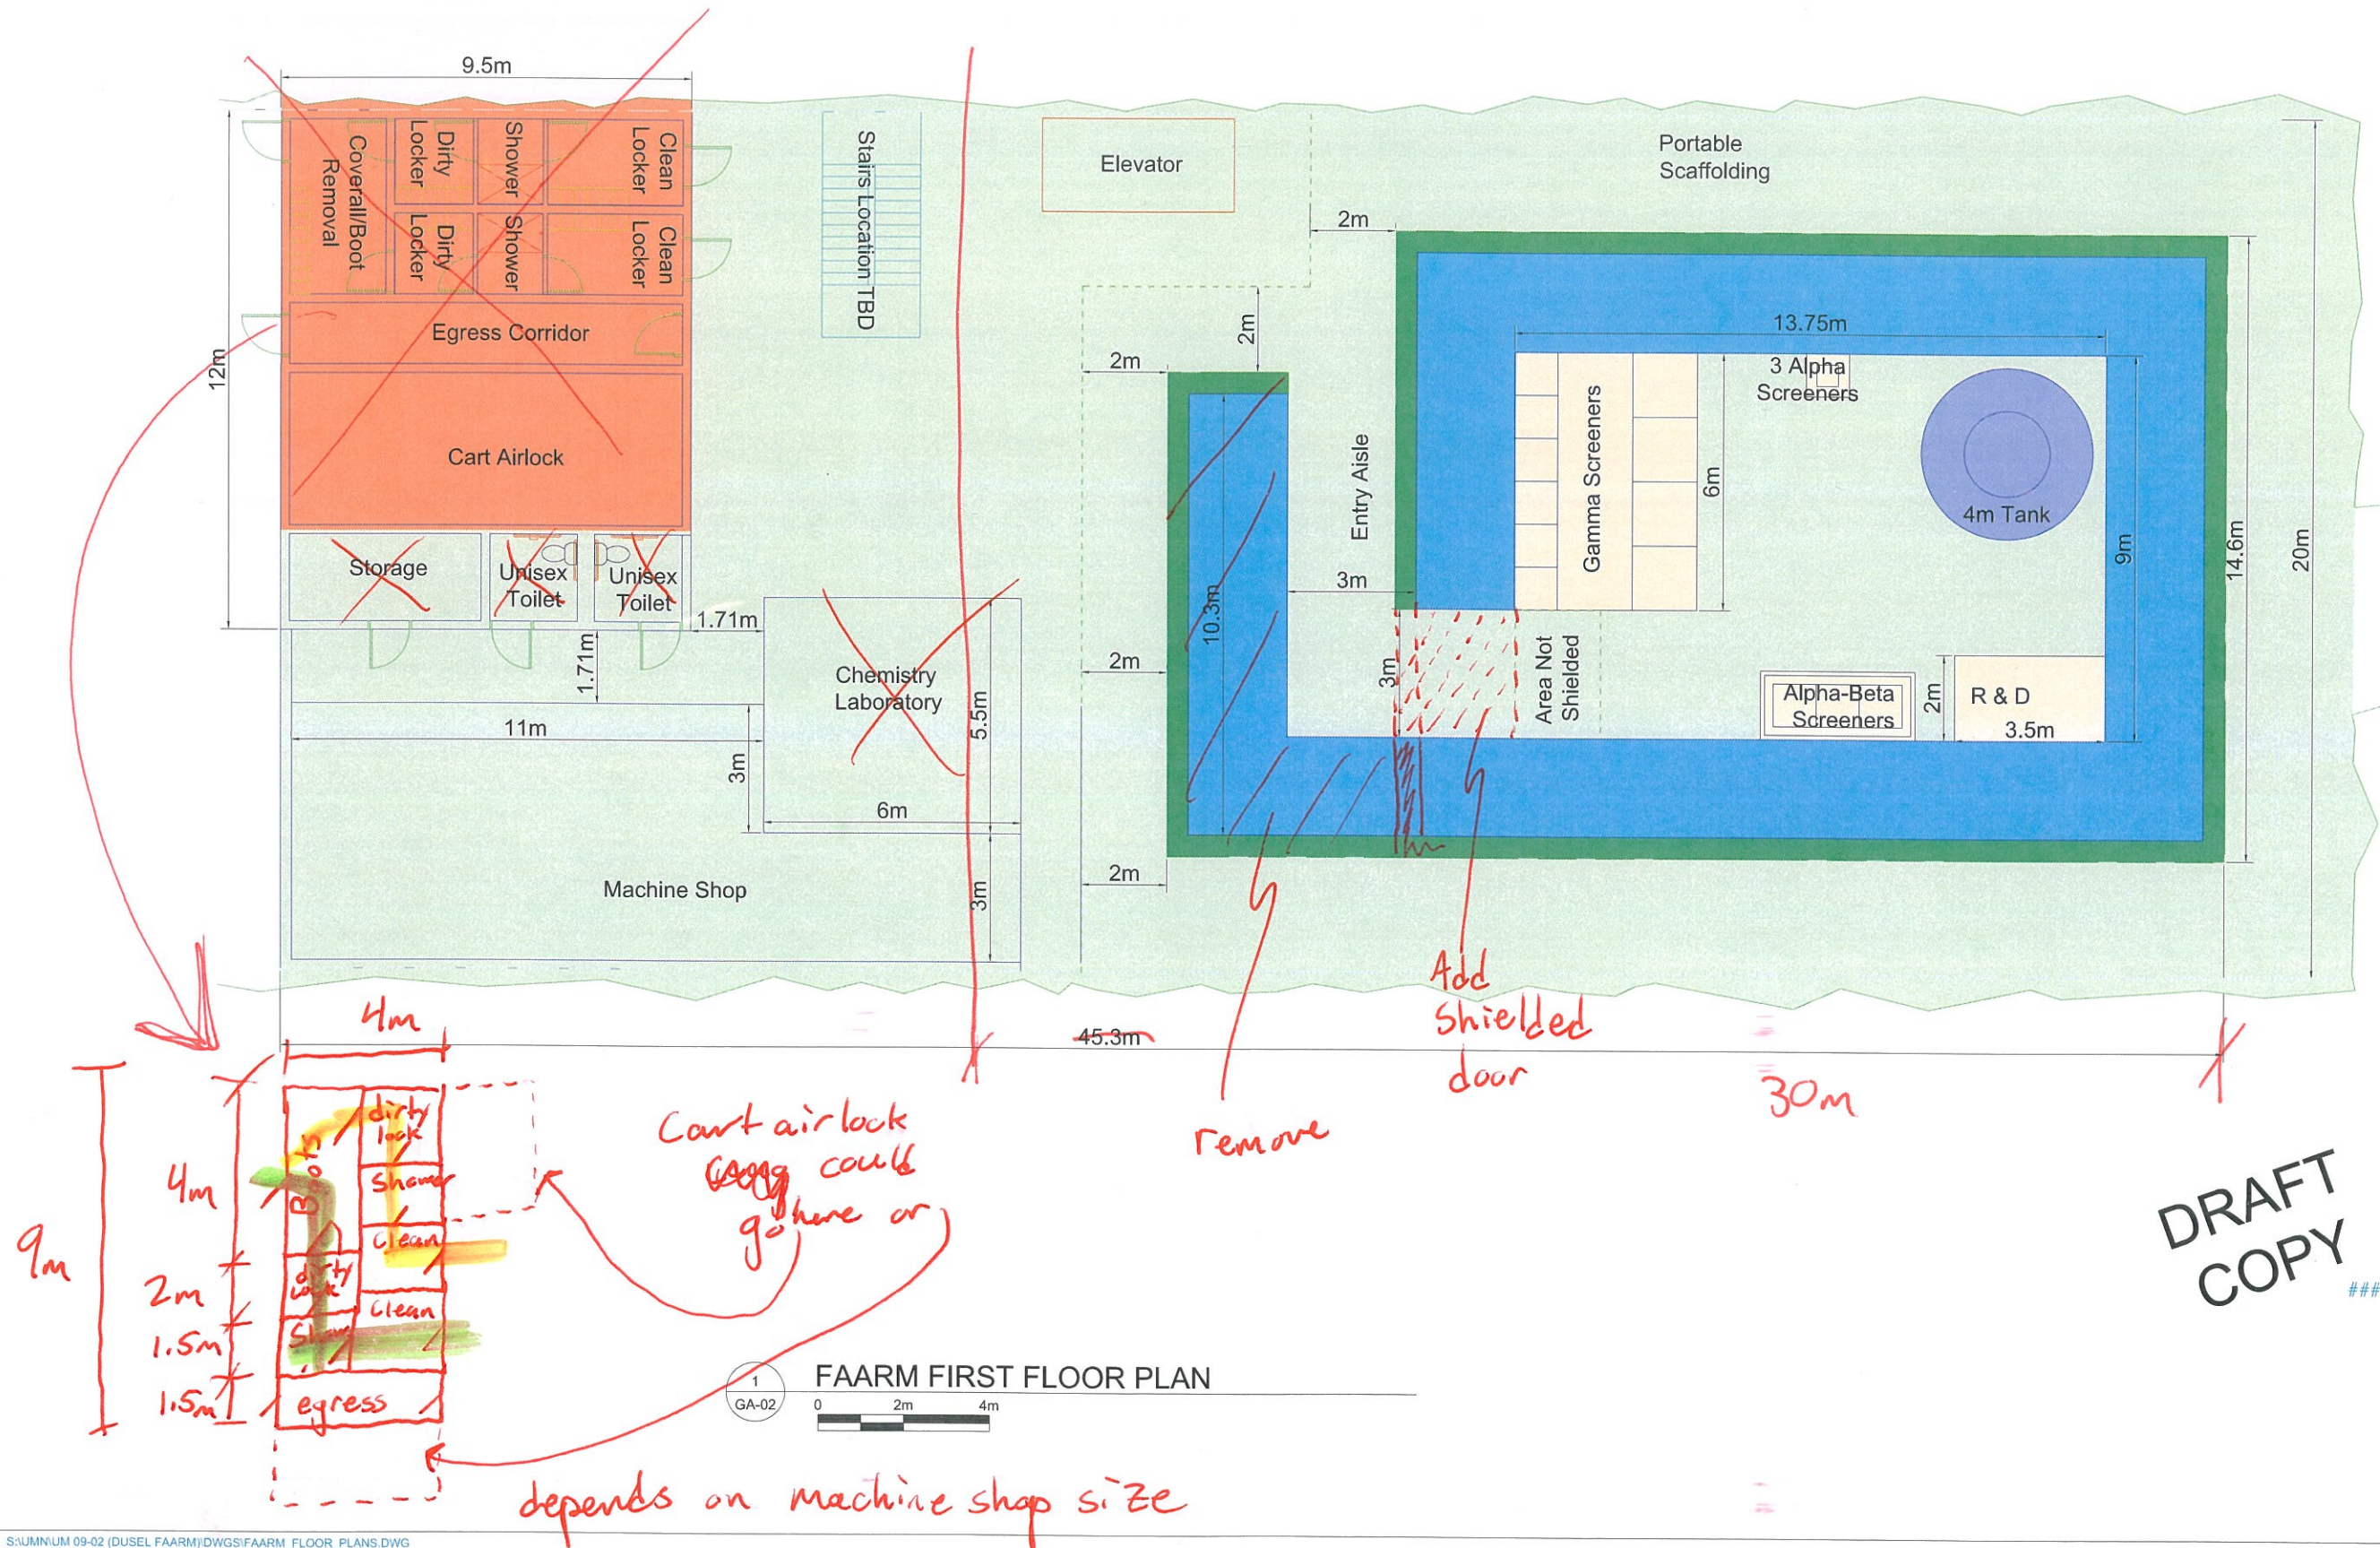

Signature _____
X Name _____
X Date _____ X License # _____

PROJECT: _____

UNIVERSITY OF MN
FAARM

CITY, STATE

REVISED:		
NO.	DATE	REMARK

COMM. NO.: CNA0902

DATE: NOVEMBER 19, 2009

DRAWN: XXX

CHECKED: XXX

DRAWING TITLE: _____


DRAWING NUMBER: _____

GA-02

- Classified Space
- Unclassified Space
- Transition Space
- Water Shield
- Tank
- Photomultiplier Tubes and Plumbing
- Experiment Equipment
- Veto Shield

CNA
Consulting Engineers

2800 University Avenue S.E.
Minneapolis, Minnesota 55414
Ph 612-379-8805
Fax 612-379-8805

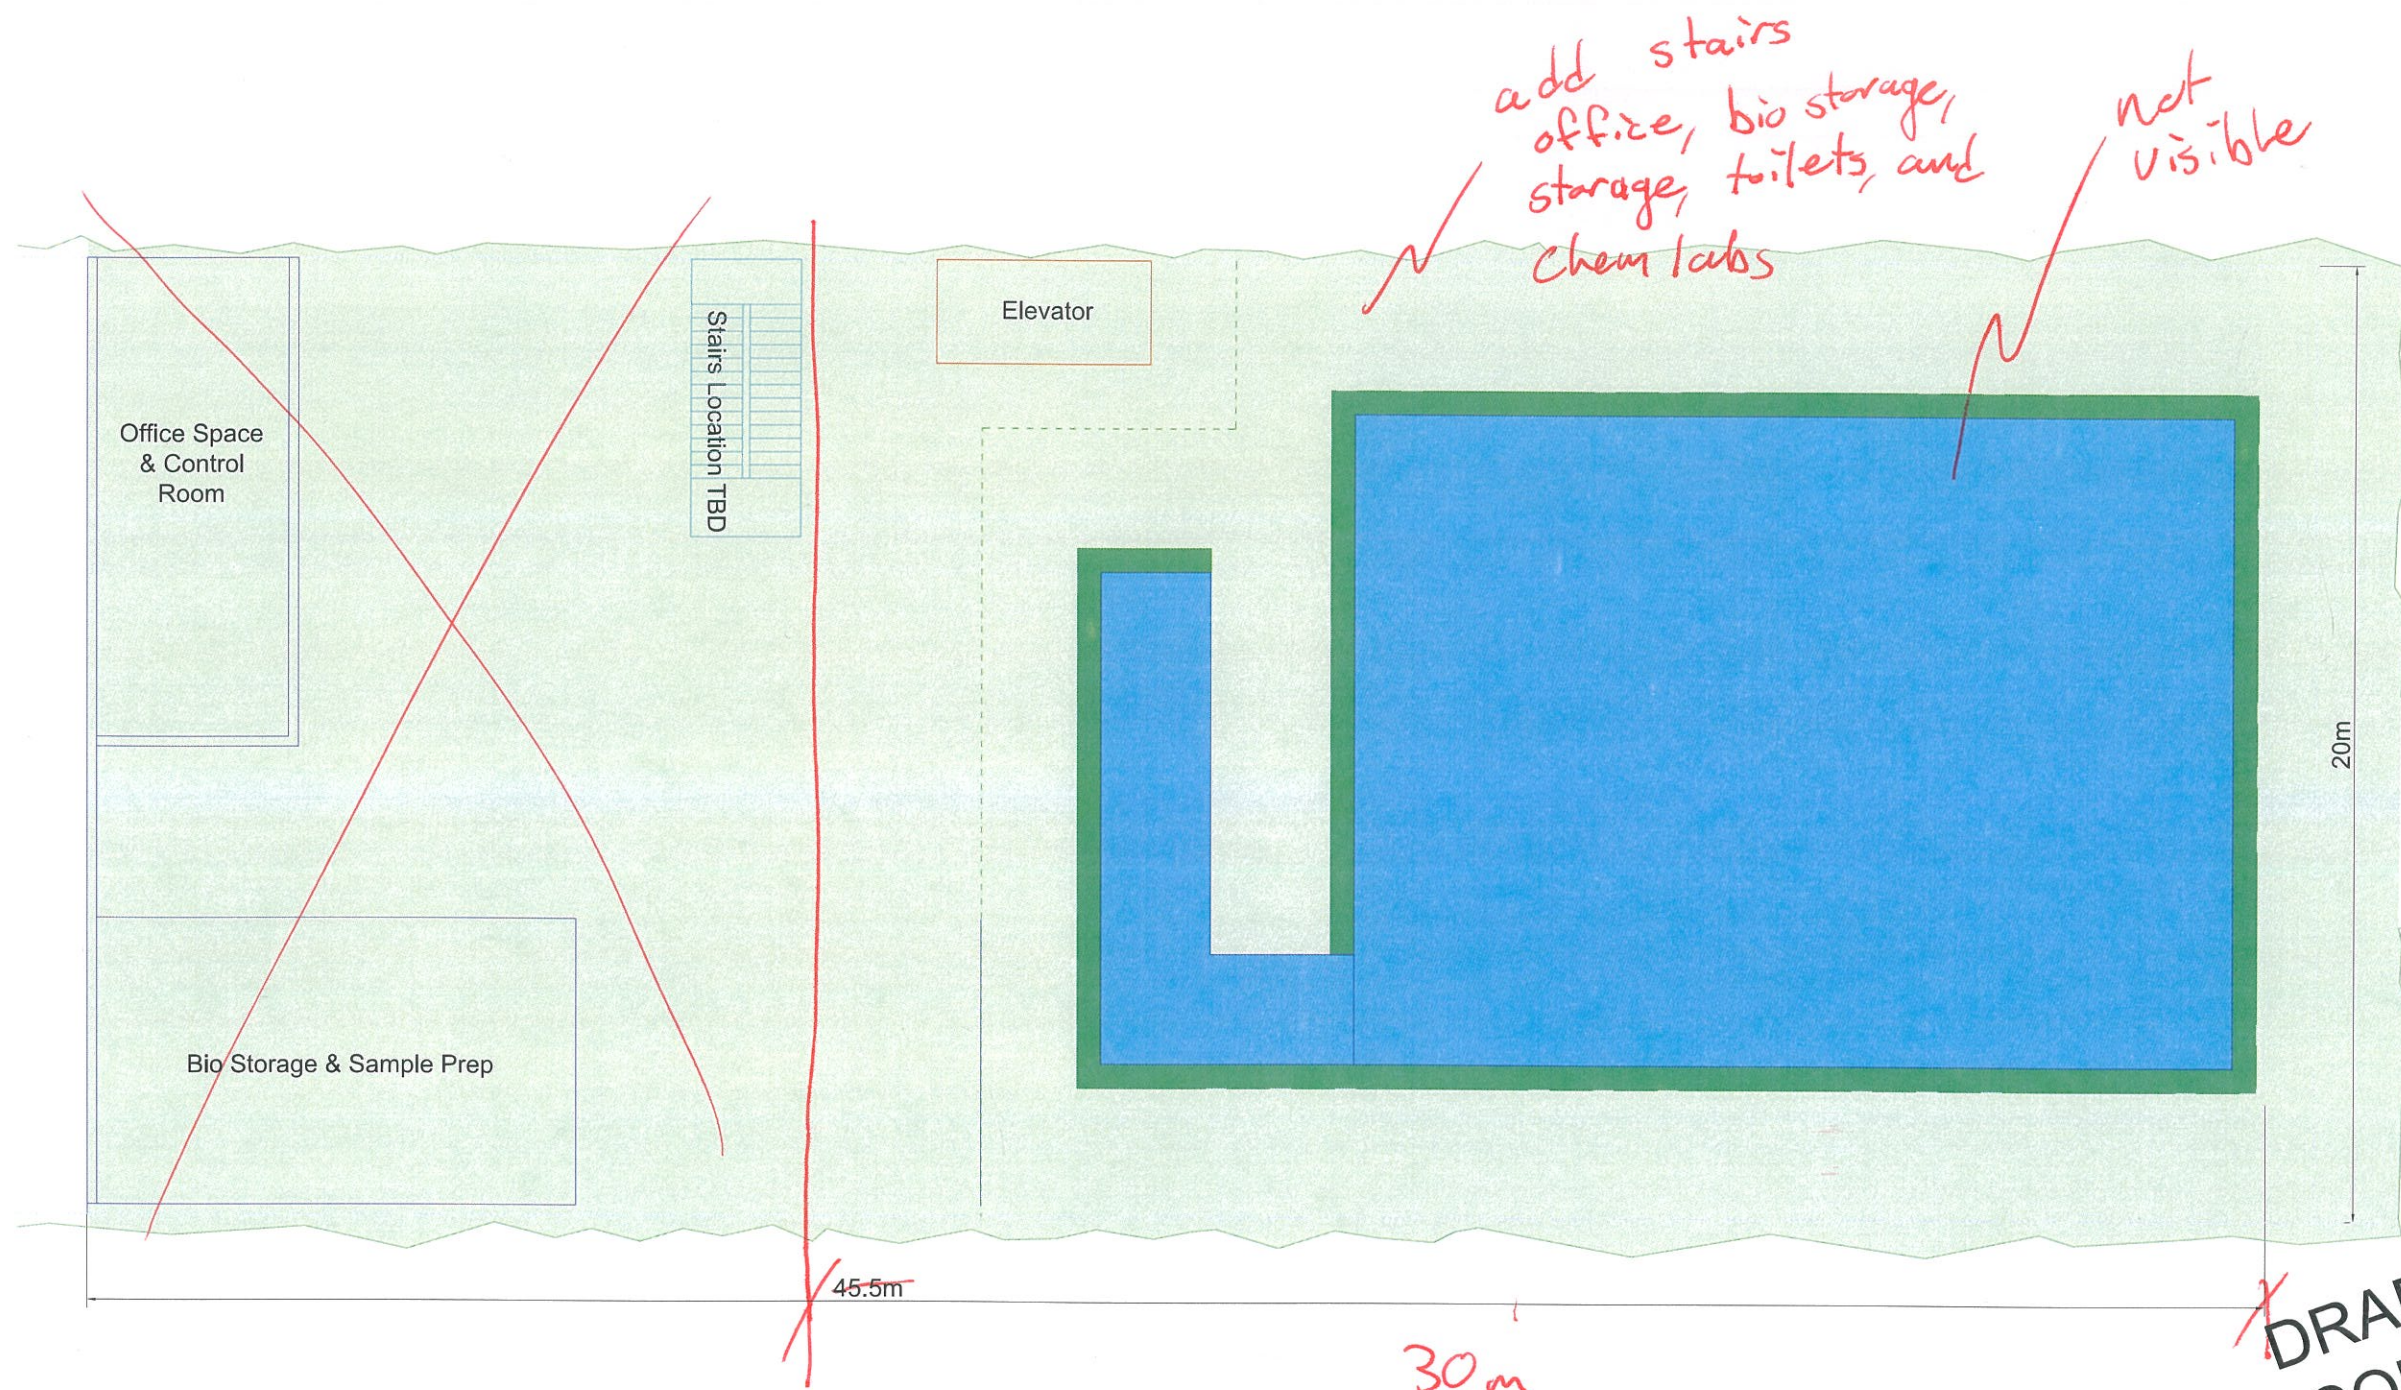

Signature _____
X
Name _____
X
Date _____ License # _____

PROJECT: _____

UNIVERSITY OF MN

FAARM

CITY, STATE

REVISED:		
NO.	DATE	REMARK
#	#	#
#	#	#
#	#	#
#	#	#
#	#	#
#	#	#
#	#	#

COMM. NO.: CNA0902

DATE: NOVEMBER 19, 2009

DRAWN: XXX

 
CHECKED: XXX

DRAWING TITLE: _____

DRAWING NUMBER: _____

GA-03

1
GA-03
FAARM SECOND FLOOR PLAN





Signature _____
X
Name _____
X
Date _____ License # _____

PROJECT: _____

UNIVERSITY OF MN

FAARM

CITY, STATE

REVISED:		
NO.	DATE	REMARK
#	#	#
#	#	#
#	#	#
#	#	#
#	#	#
#	#	#
#	#	#

COMM. NO.: CNA0902

DATE: NOVEMBER 19, 2009

DRAWN: XXX

CHECKED: XXX


DRAWING TITLE: _____

DRAWING NUMBER: _____

GA-04

1
GA-04
FAARM THIRD FLOOR PLAN
0 2m 4m


- | | |
|--------------------|------------------------------------|
| Classified Space | Tank |
| Unclassified Space | Photomultiplier Tubes and Plumbing |
| Transition Space | Experiment Equipment |
| Water Shield | Veto Shield |

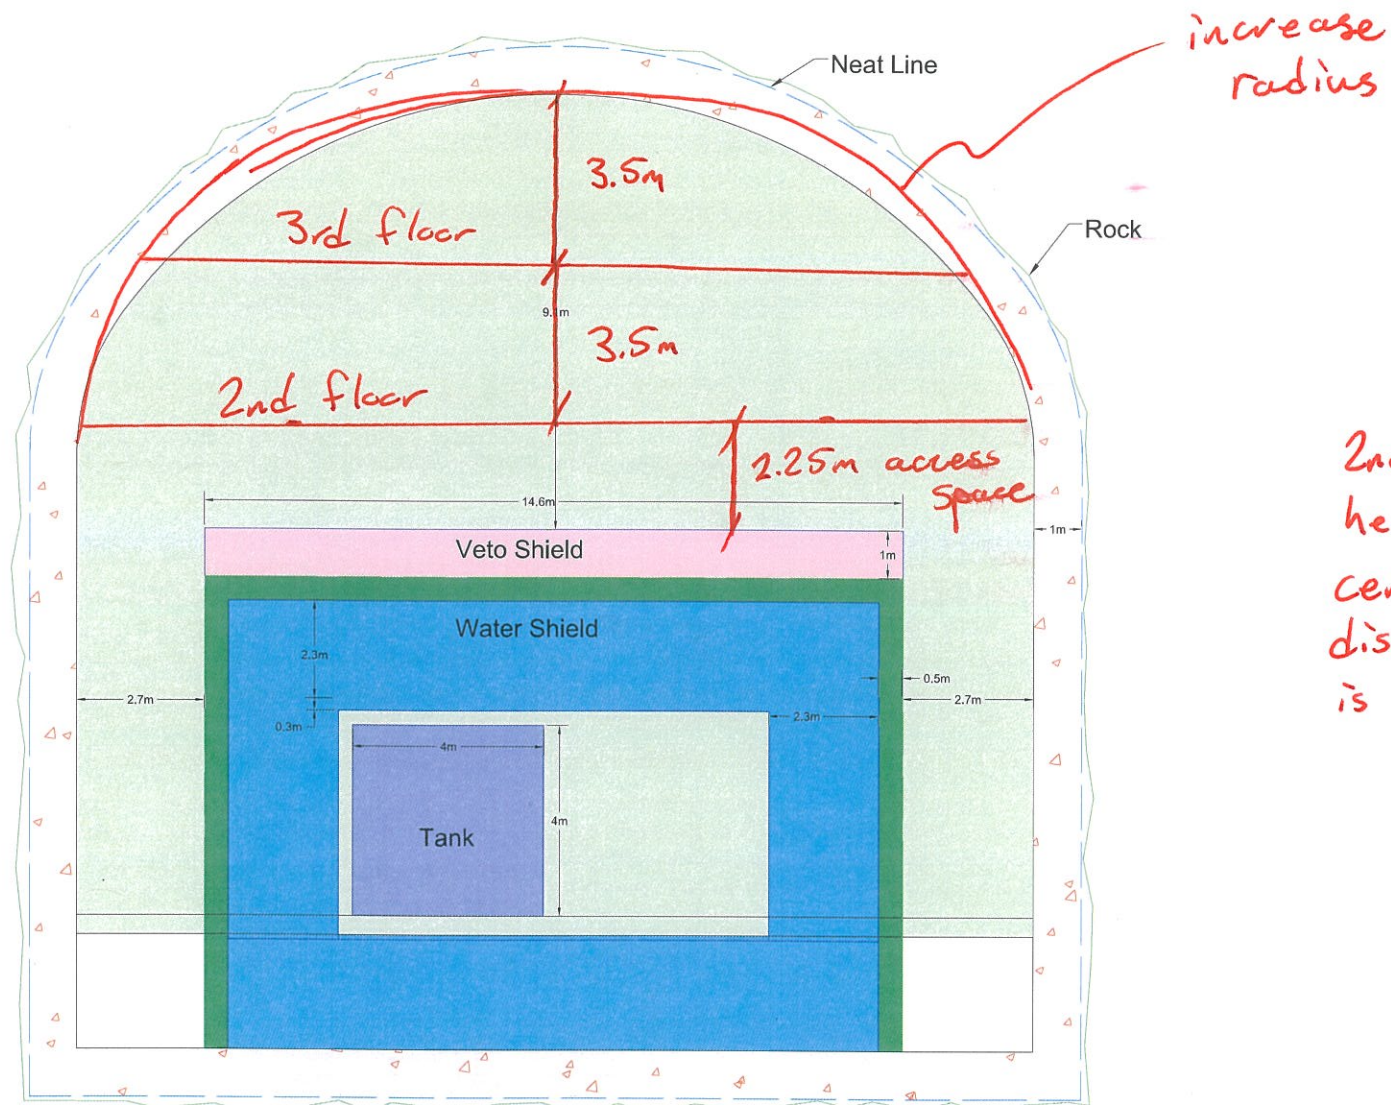

2nd and 3rd floor
heights are
center-on-center
distances (floor thickness
is not accounted for)

1
GA-05

 Experiment Room Section



**DRAFT
COPY**

Signature _____
X
Name _____
X
Date _____ License # _____

PROJECT:

UNIVERSITY OF MN

FAARM

CITY, STATE

REVISED:

NO.	DATE	REMARK
#	#	#
#	#	#
#	#	#
#	#	#
#	#	#
#	#	#
#	#	#

COMM. NO.: CNA0902

DATE: NOVEMBER 19, 2009

DRAWN: XXX

CHECKED: XXX

DRAWING TITLE:

#####

DRAWING NUMBER:

GA-05