

- Classified Space


Unclassified Space

Transition Space

Water Shield
- Tank

Photomultiplier Tubes and Plumbing

Experiment Equipment

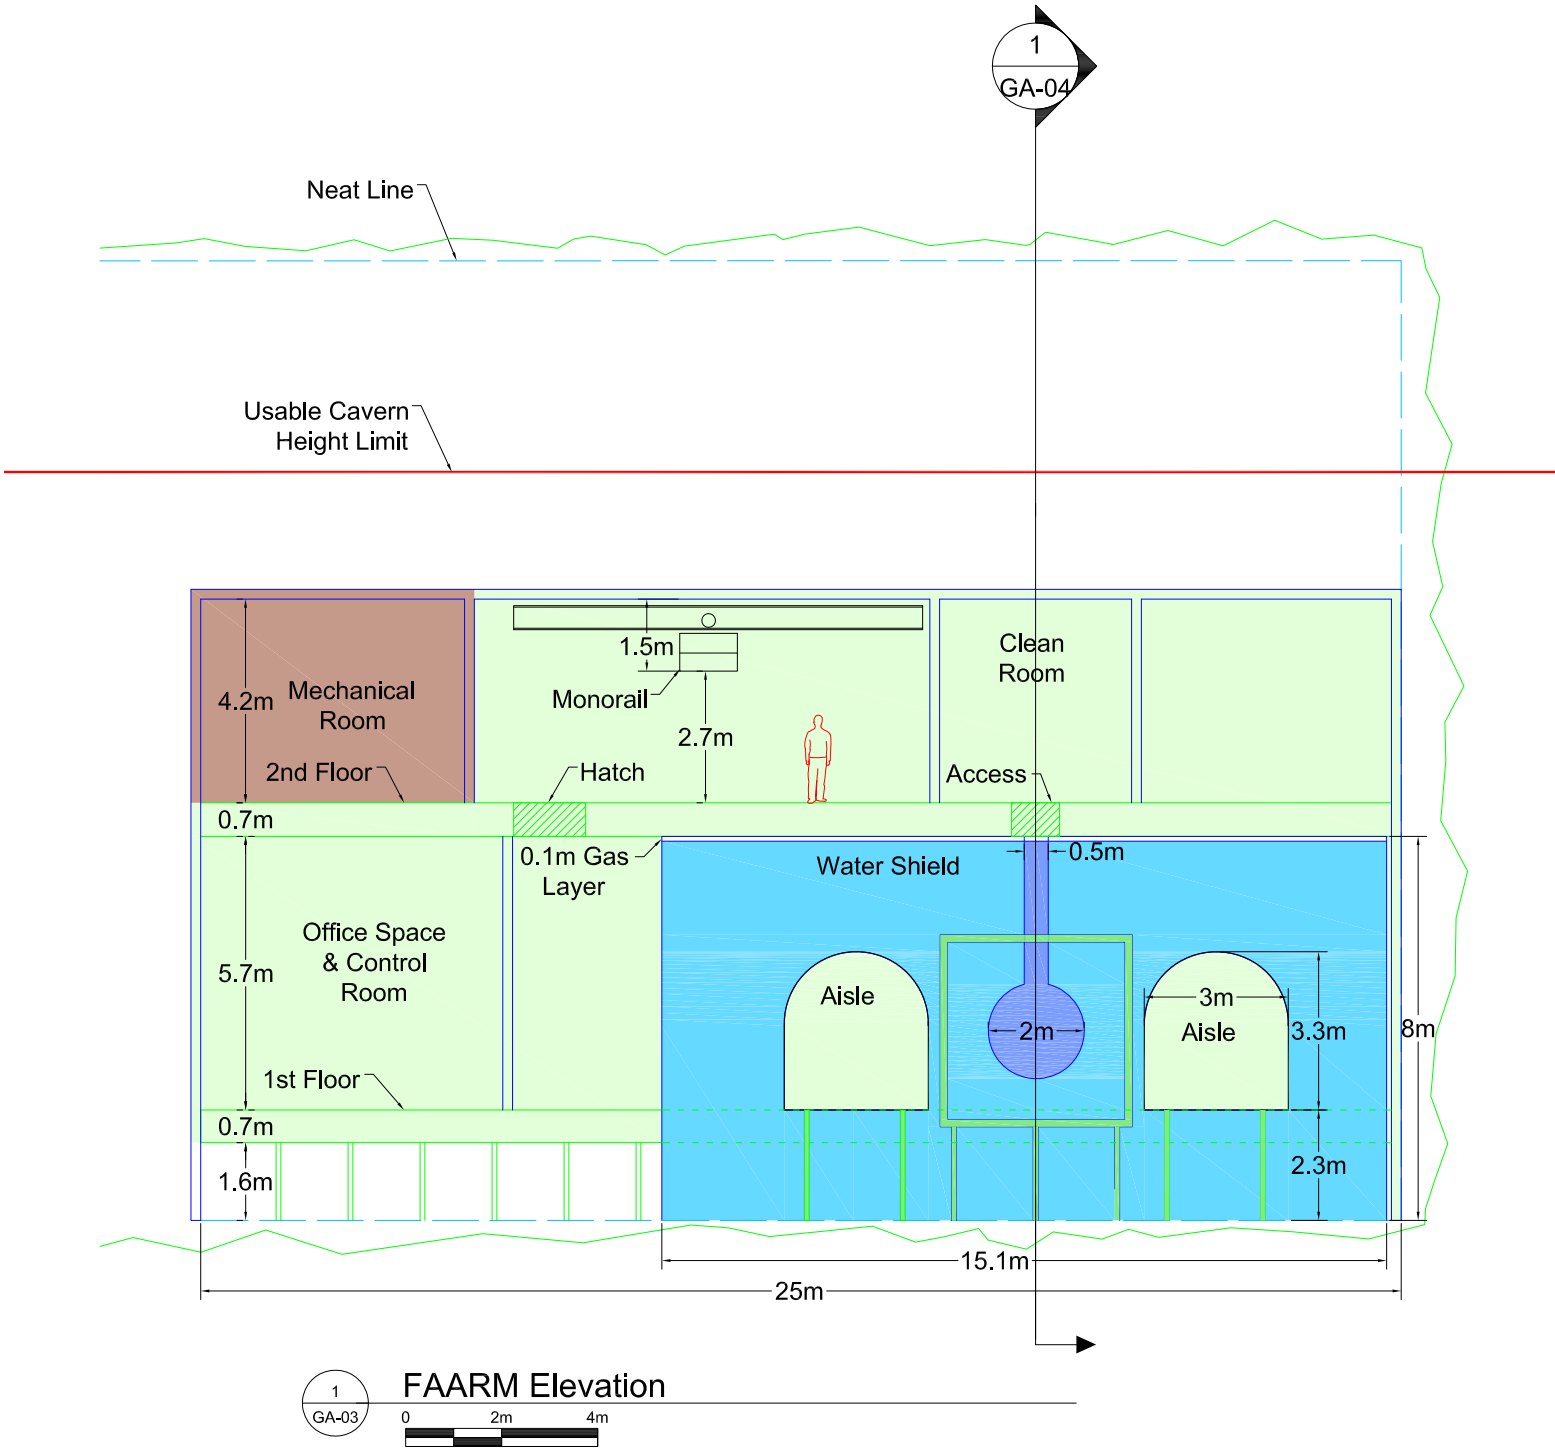

Signature _____
X
Name _____
X X
Date _____ License # _____

PROJECT _____

UNIVERSITY OF MN
FAARM

CITY, STATE

REVISED		
NO.	DATE	REMARK
#	#	#
#	#	#
#	#	#
#	#	#
#	#	#
#	#	#
#	#	#


COMM. NO.: CNA0902
DATE: April 02, 2010
DRAWN: XXX
CHECKED: XXX

DRAWING TITLE _____

DRAWING NUMBER _____

GA-01

- Classified Space
- Unclassified Space
- Transition Space
- Water Shield
- Tank
- Photomultiplier Tubes and Plumbing
- Experiment Equipment

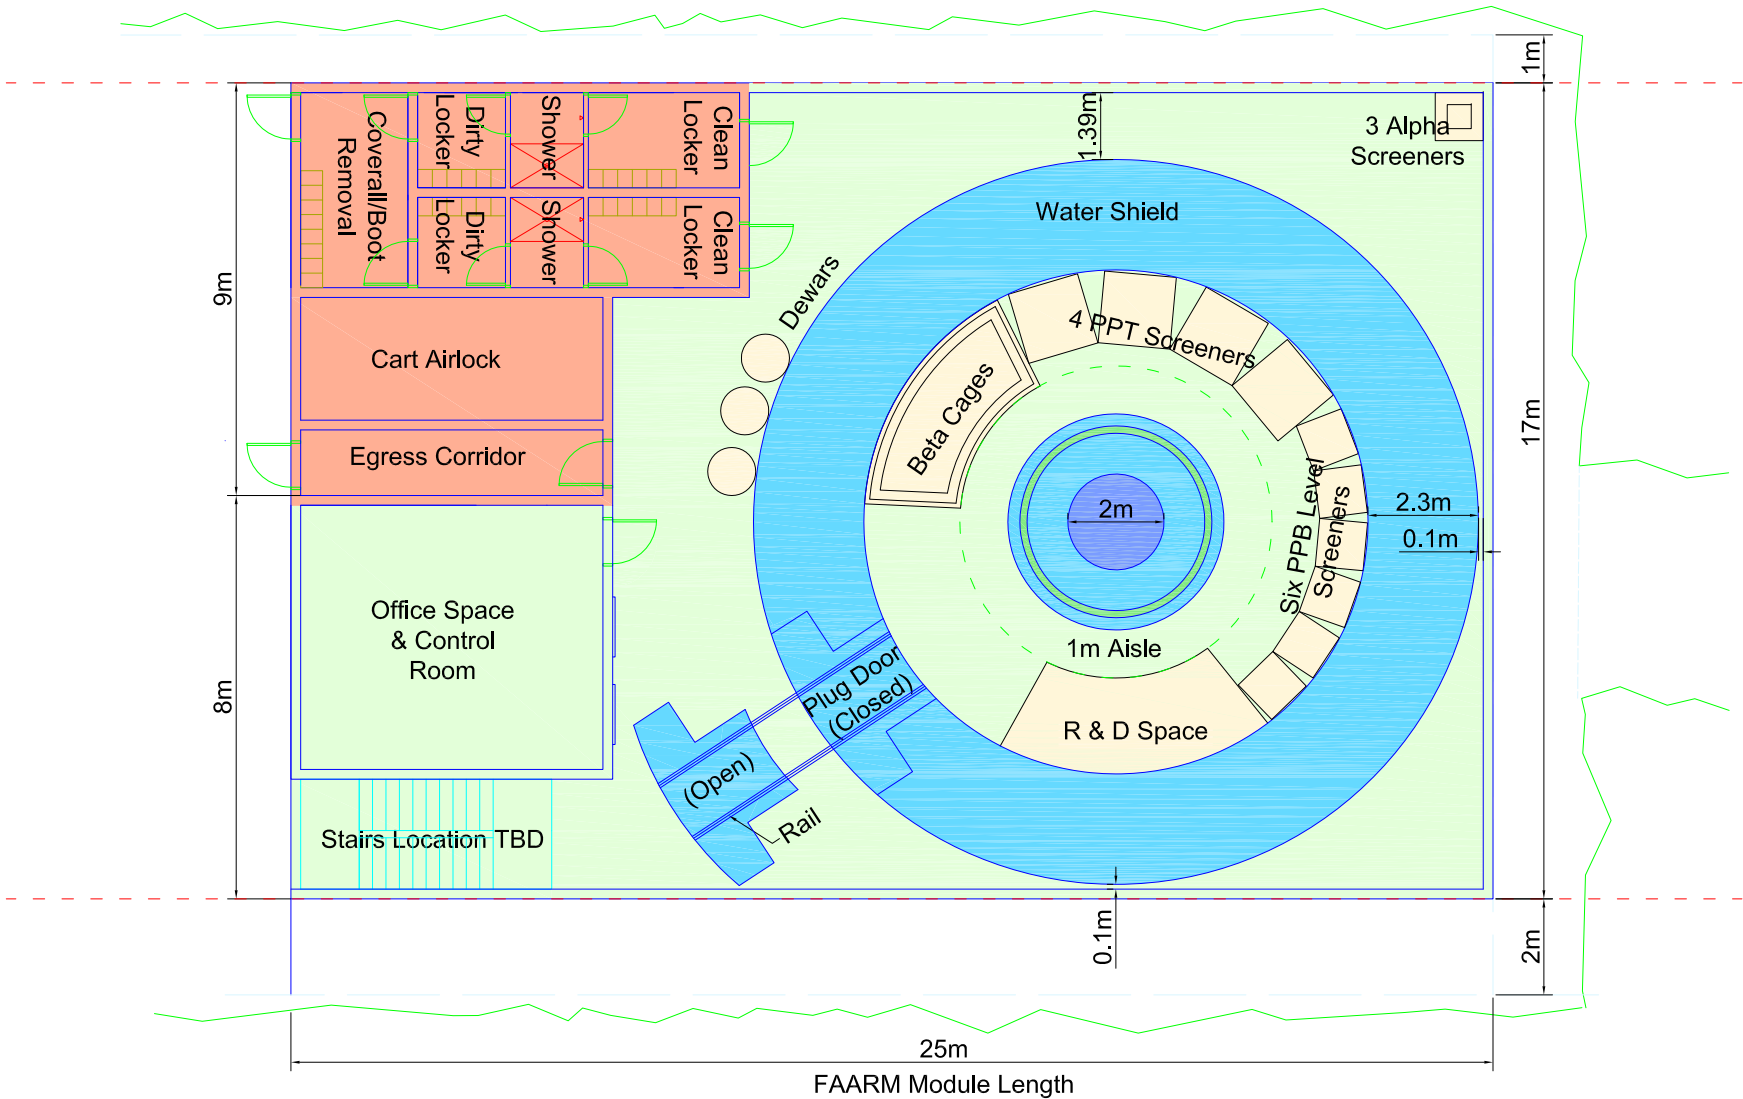

1
GA-01

First Floor Plan



DRAFT
COPY

Signature

X

Name

X

Date

X

License #

PROJECT:

UNIVERSITY OF MN

FAARM

CITY, STATE

REVISED

NO.	DATE	REMARK
#	#	#
#	#	#
COMM. NO.:

CNA0902

DATE:

April 02, 2010

DRAWN:

XXX

CHECKED:

XXX

DRAWING TITLE:

DRAWING NUMBER:

GA-02

- Classified Space


Unclassified Space

Transition Space

Water Shield
- Tank

Photomultiplier Tubes and Plumbing

Experiment Equipment

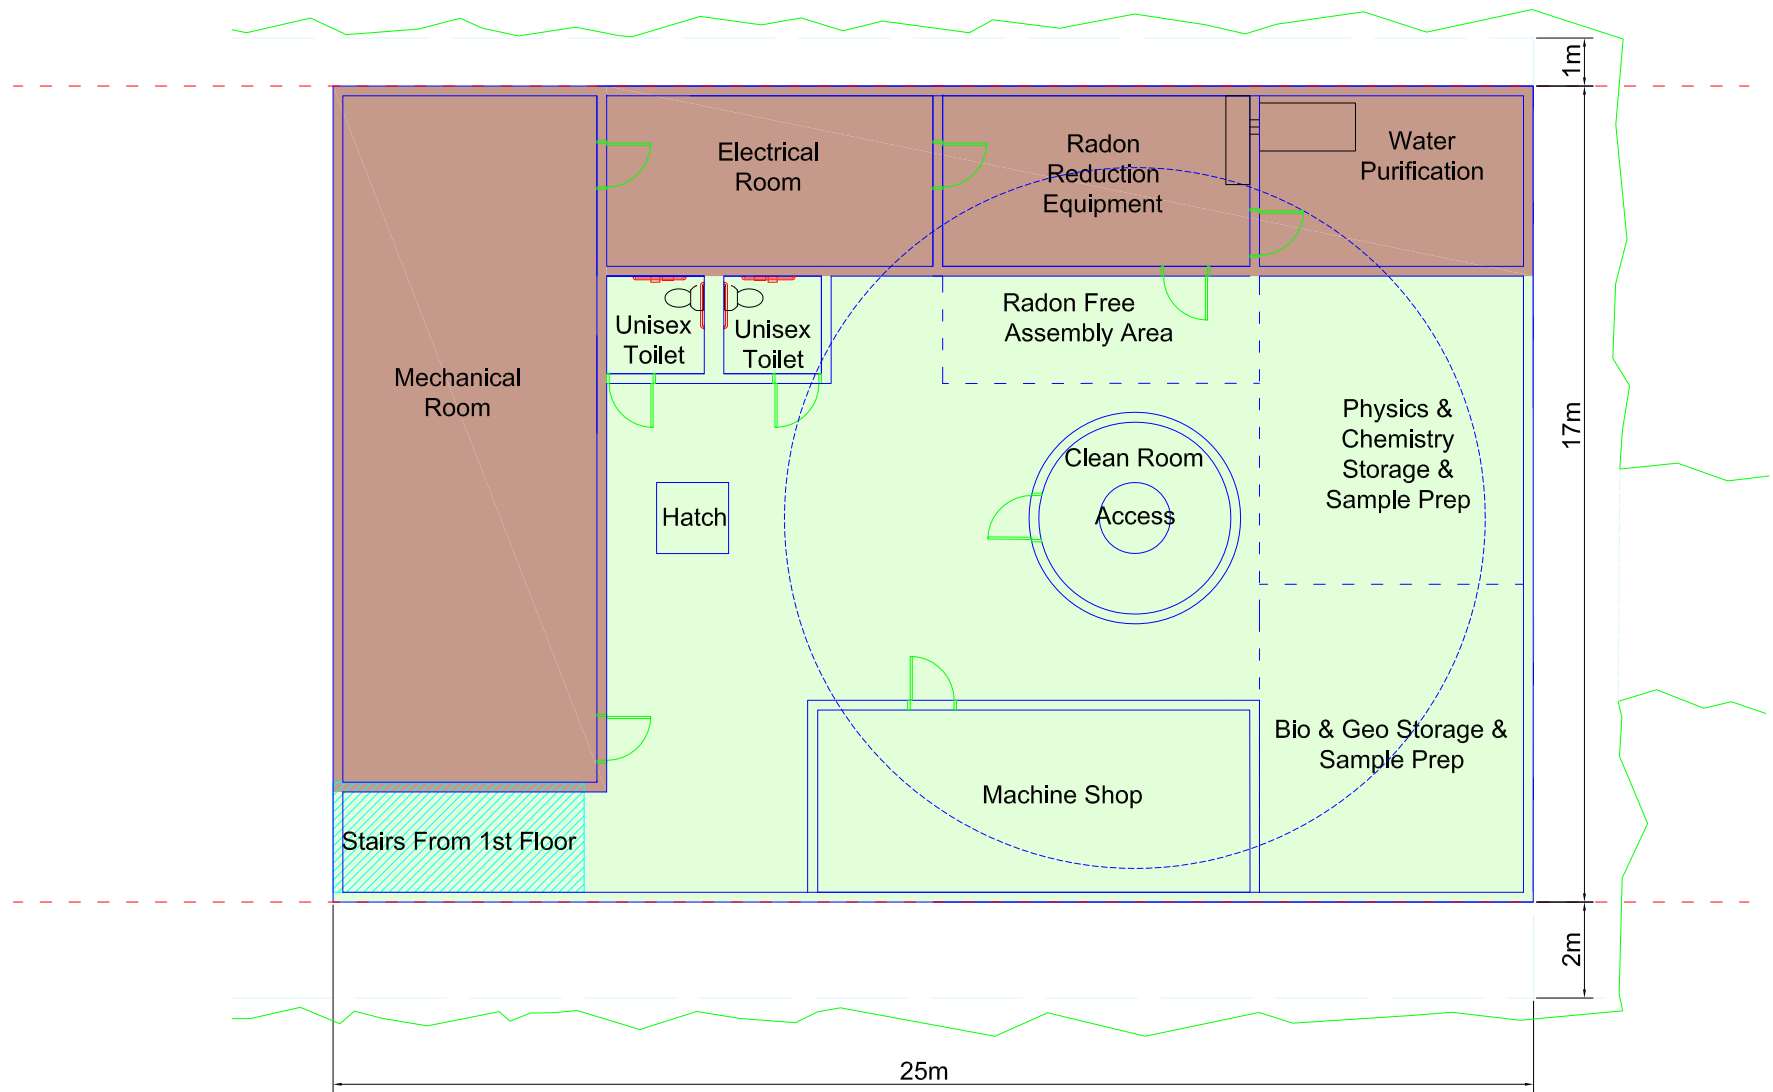

Second Floor Plan

DRAFT
COPY

Signature
X
Name
X
Date
X
License #

PROJECT:

UNIVERSITY OF MN

FAARM

CITY, STATE

REVISED		
NO.	DATE	REMARK
#	#	#
#	#	#
#	#	#
#	#	#
#	#	#
#	#	#
#	#	#
#	#	#

COMM. NO.: CNA0902

DATE: April 02, 2010

DRAWN: XXX

CHECKED: XXX

DRAWING TITLE:

DRAWING NUMBER:

GA-02

- Classified Space


Unclassified Space

Transition Space

Water Shield
- Tank

Photomultiplier Tubes and Plumbing

Experiment Equipment

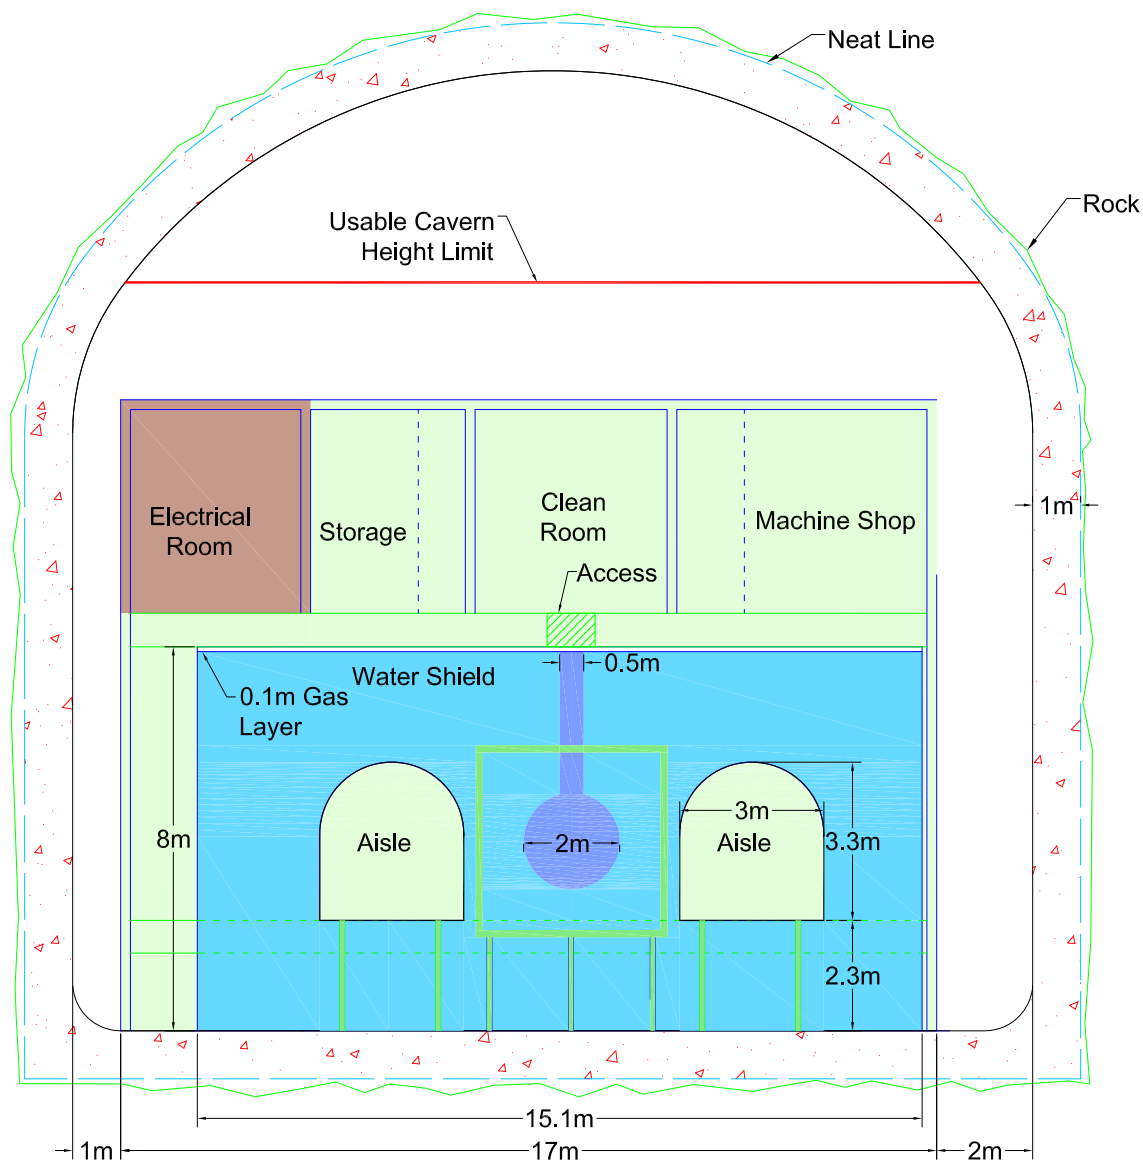

1
GA-04

Water Shield Section

0 2m 4m

DRAFT
COPY

Signature

X

Name

X

Date

X

License #

PROJECT

UNIVERSITY OF MN

FAARM

CITY, STATE

REVISED

NO.	DATE	REMARK
#	#	#
#	#	#
COMM. NO.:

CNA0902

DATE:

April 02, 2010

DRAWN:

XXX

CHECKED:

XXX

DRAWING TITLE:

DRAWING NUMBER:

GA-04