


- Classified Space
- Unclassified Space
- Transition Space
- Water Shield
- Tank
- Photomultiplier Tubes and Plumbing
- Experiment Equipment

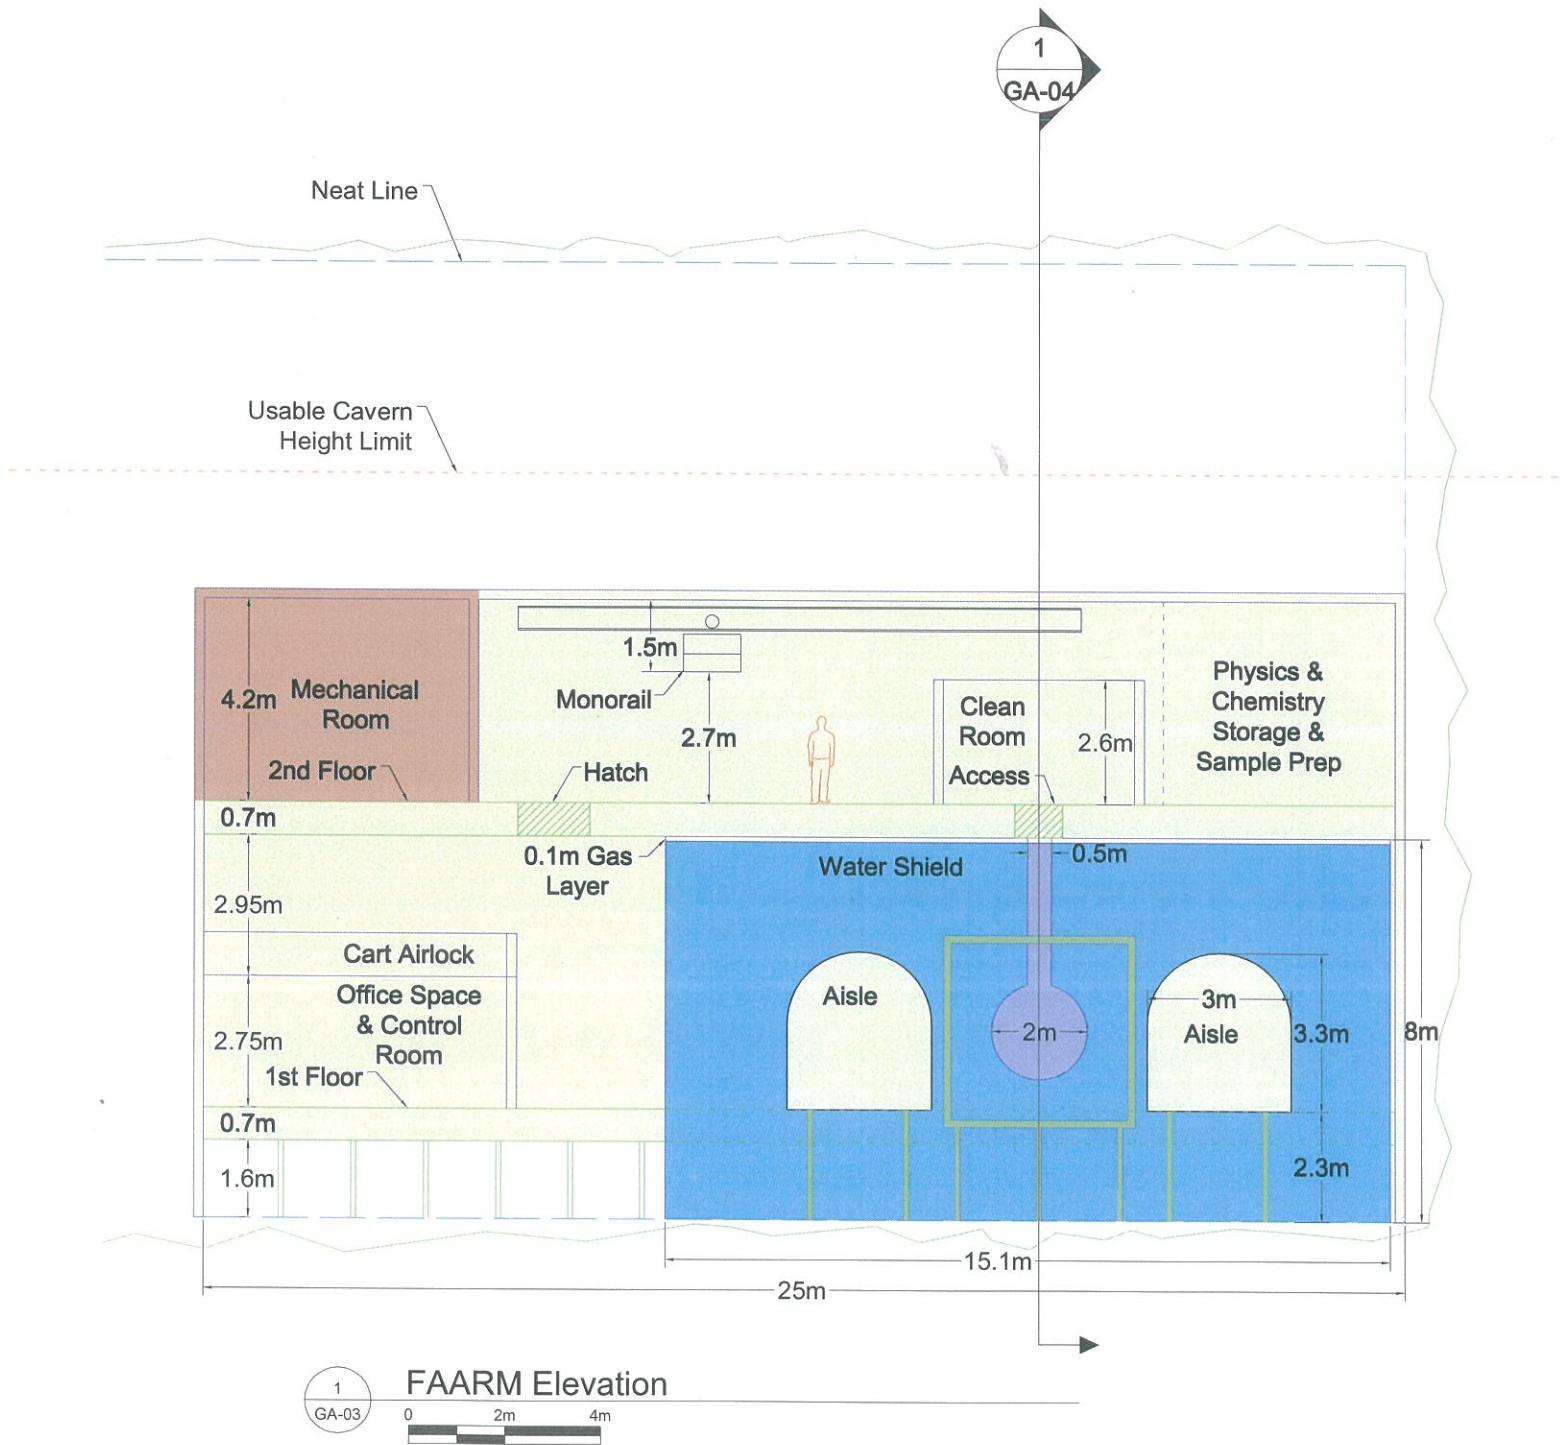

DRAFT
COPY

Signature
X
Name
X X
Date License #

PROJECT:

UNIVERSITY OF MN

FAARM

CITY, STATE

REVISED		
NO.	DATE	REMARK

COMM. NO.: CNA0902

DATE: April 02, 2010

DRAWN: XXX


CHECKED: XXX

DRAWING TITLE:

DRAWING NUMBER:

GA-01

- Classified Space
- Unclassified Space
- Transition Space
- Water Shield
- Tank
- Photomultiplier Tubes and Plumbing
- Experiment Equipment

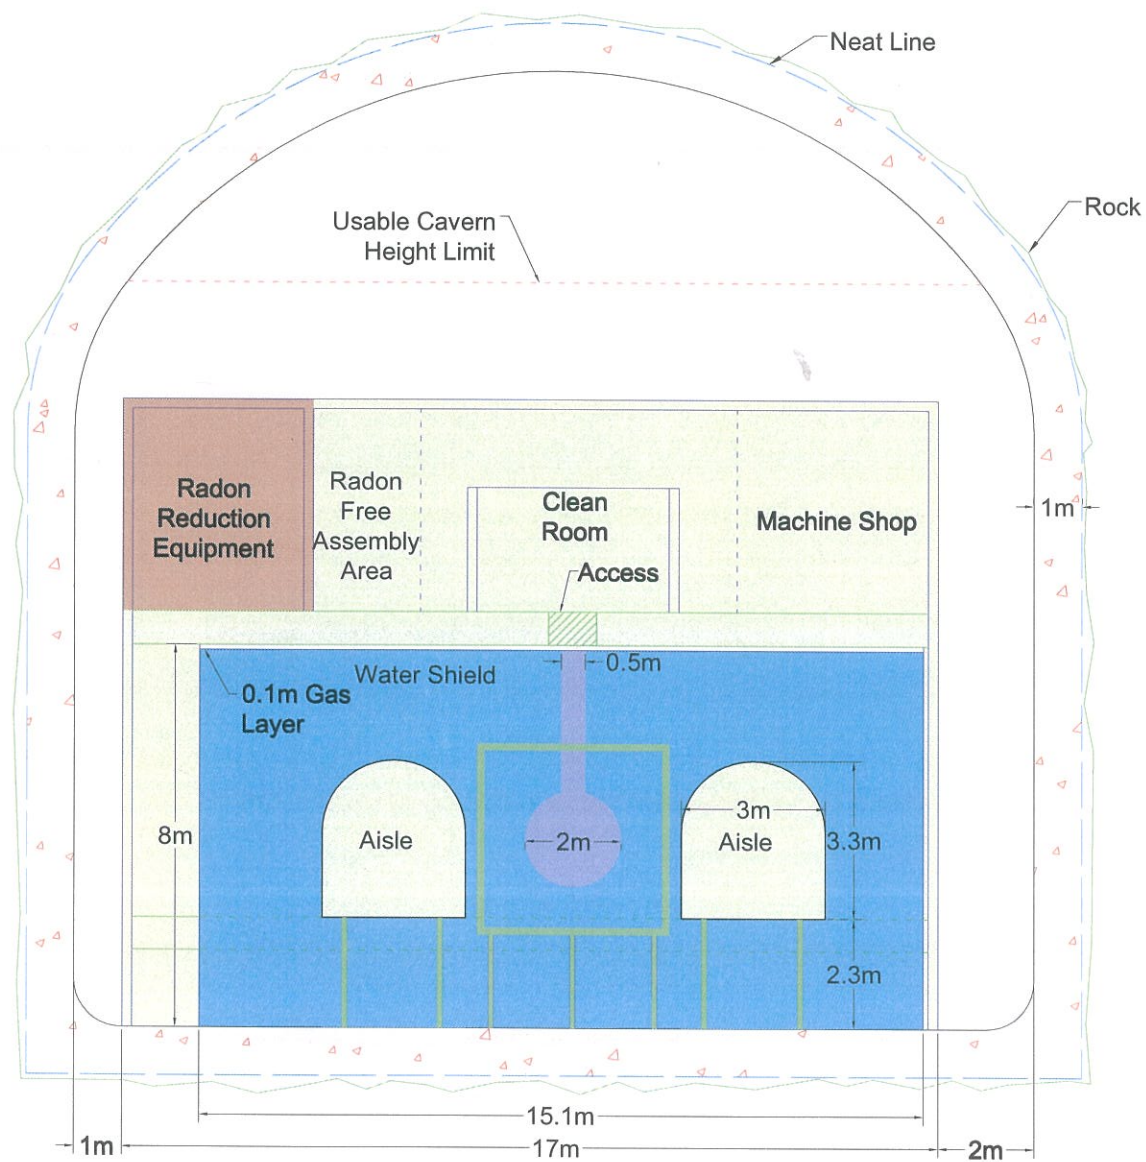

1
GA-04
Water Shield Section
0 2m 4m

DRAFT
COPY

Signature
X
Name
X X
Date License #

PROJECT:

UNIVERSITY OF MN
FAARM

CITY, STATE

REVISED:		
NO.	DATE	REMARK
1		
2		
3		
4		
5		
6		
7		
8		
9		
10		

COMM. NO.: CNA0902

DATE: April 02, 2010

DRAWN: XXX


CHECKED: XXX

DRAWING TITLE:

DRAWING NUMBER:

GA-04

- Classified Space
- Unclassified Space
- Transition Space
- Water Shield
- Tank
- Photomultiplier Tubes and Plumbing
- Experiment Equipment

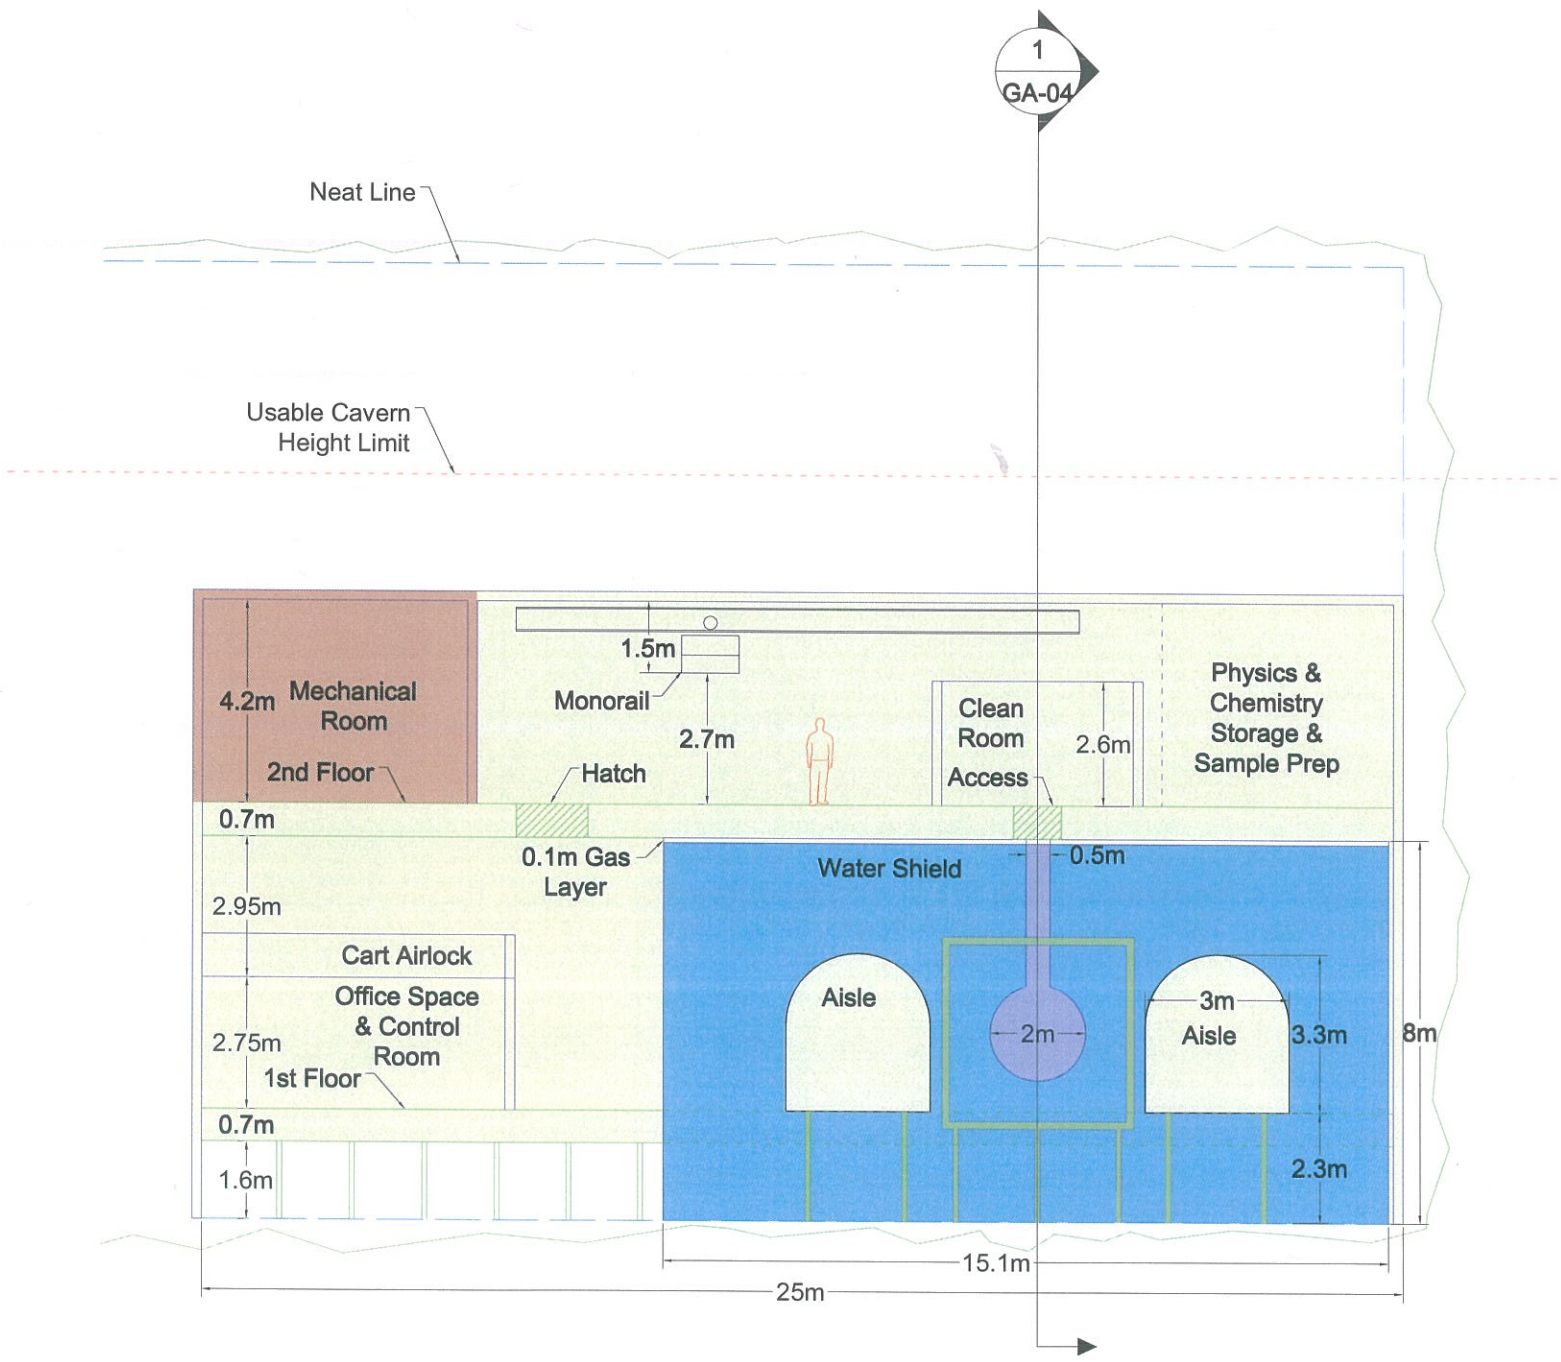

1
GA-03
FAARM Elevation
0 2m 4m

DRAFT
COPY

Signature
X
Name
X
Date
X
License #

PROJECT:

UNIVERSITY OF MN
FAARM

CITY, STATE

REVISED		
NO.	DATE	REMARK


COMM. NO.: CNA0902
DATE: April 02, 2010
DRAWN: XXX
CHECKED: XXX

DRAWING TITLE:

DRAWING NUMBER:

GA-01

- Classified Space
- Unclassified Space
- Transition Space
- Water Shield
- Tank
- Photomultiplier Tubes and Plumbing
- Experiment Equipment

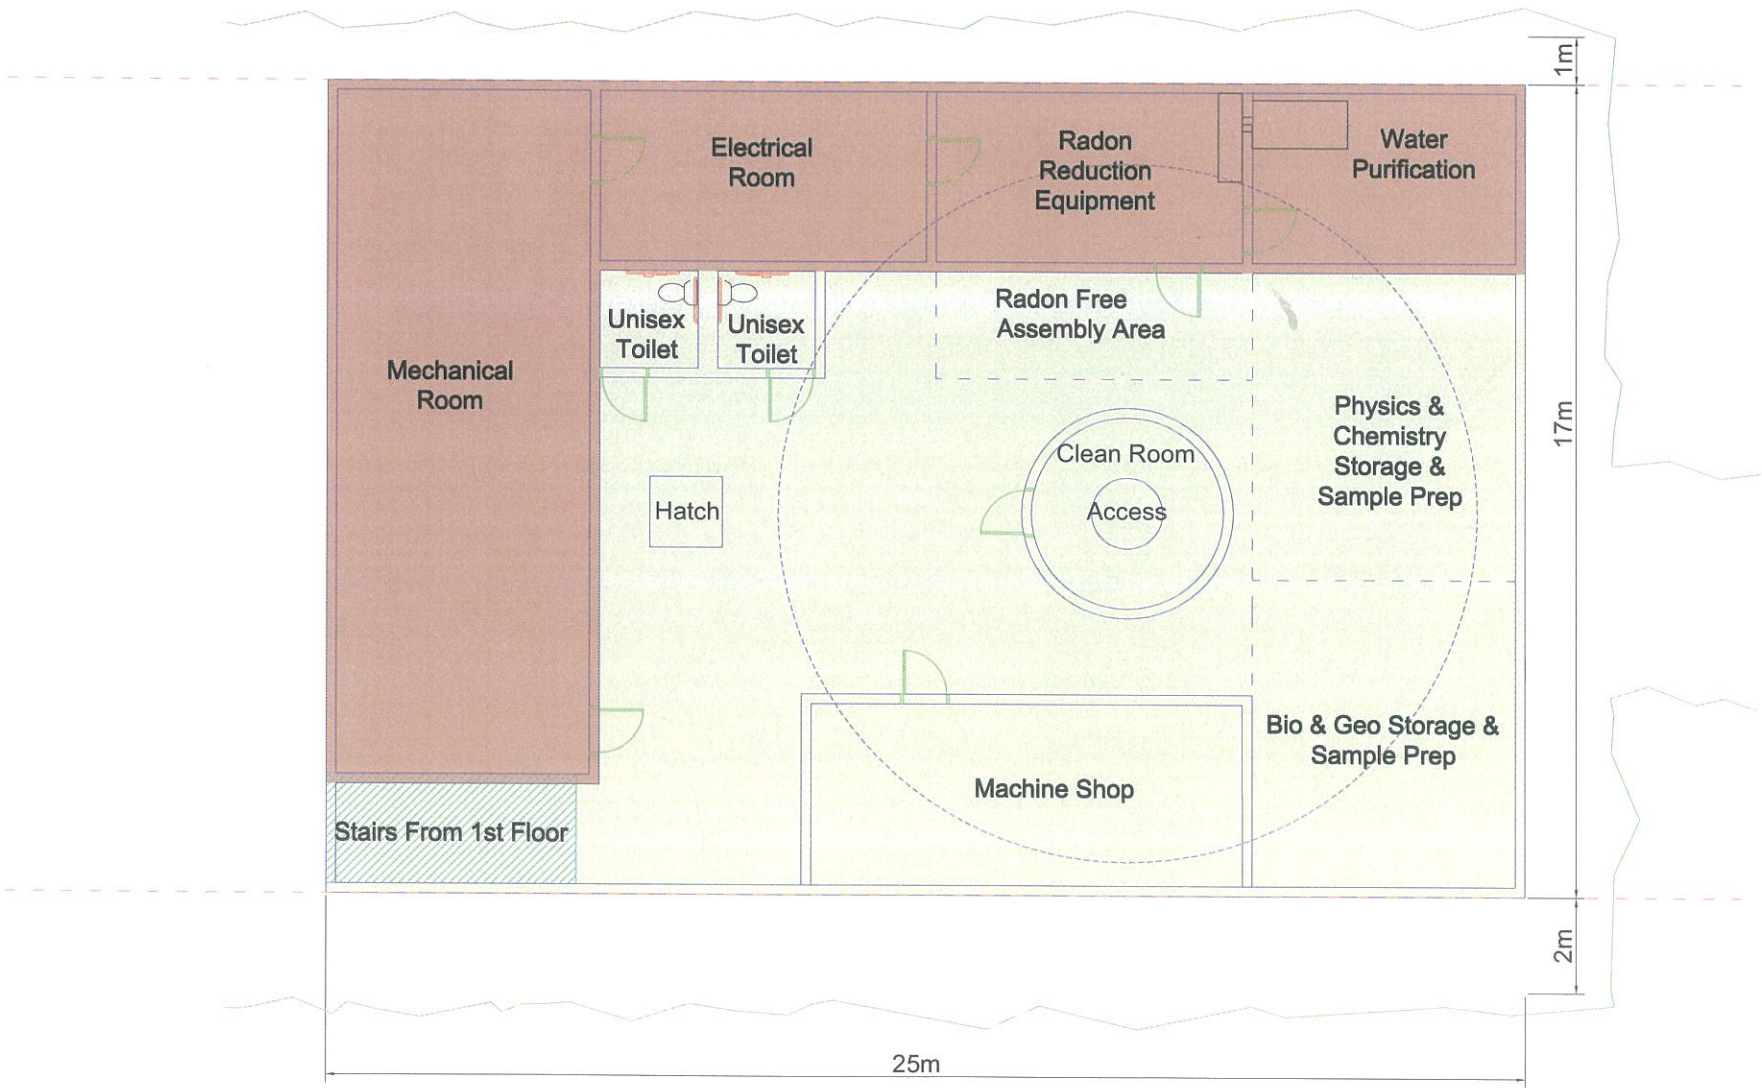

1
GA-02
Second Floor Plan
0 2m 4m

DRAFT
COPY

Signature
X
Name
X
Date
X License #

PROJECT:

UNIVERSITY OF MN
FAARM

CITY, STATE


REVISED:		
NO.	DATE	REMARK

COMM. NO.: CNA0902
DATE: April 02, 2010
DRAWN: XXX
CHECKED: XXX

DRAWING TITLE:

DRAWING NUMBER:

GA-02

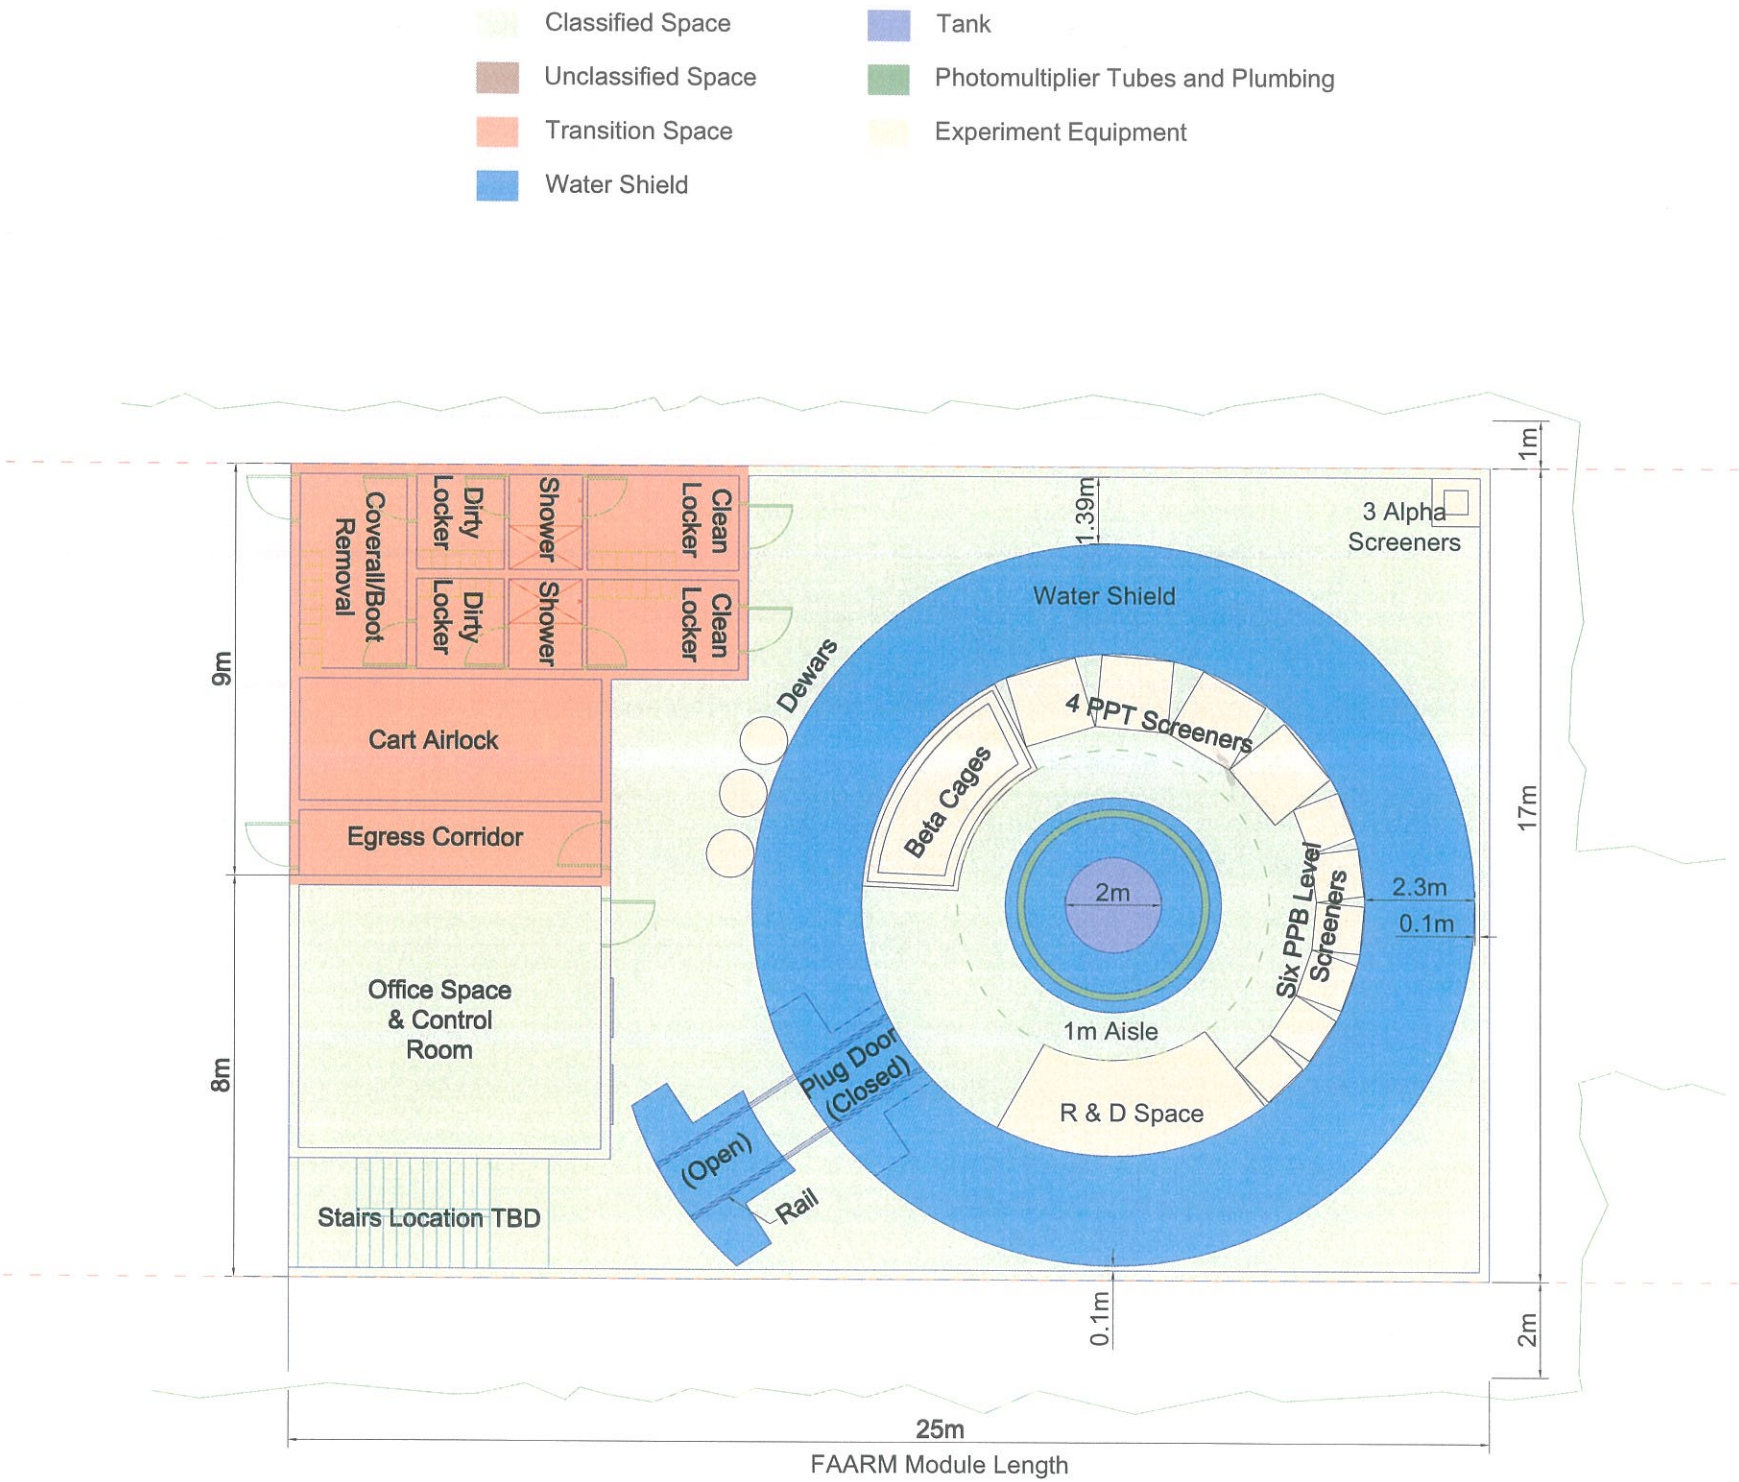

1
GA-01
First Floor Plan
0 2m 4m

DRAFT
COPY

Signature _____
X
Name _____
X X
Date _____ License # _____

PROJECT: _____

UNIVERSITY OF MN
FAARM

CITY, STATE

REVISED:		
NO.	DATE	REMARK
#	#	#
#	#	#
#	#	#
#	#	#
#	#	#
#	#	#
#	#	#

COMM. NO.: CNA0902
DATE: April 02, 2010
DRAWN: XXX
CHECKED: XXX

DRAWING TITLE: _____

DRAWING NUMBER: _____

GA-02