

- Classified Space

Unclassified Space

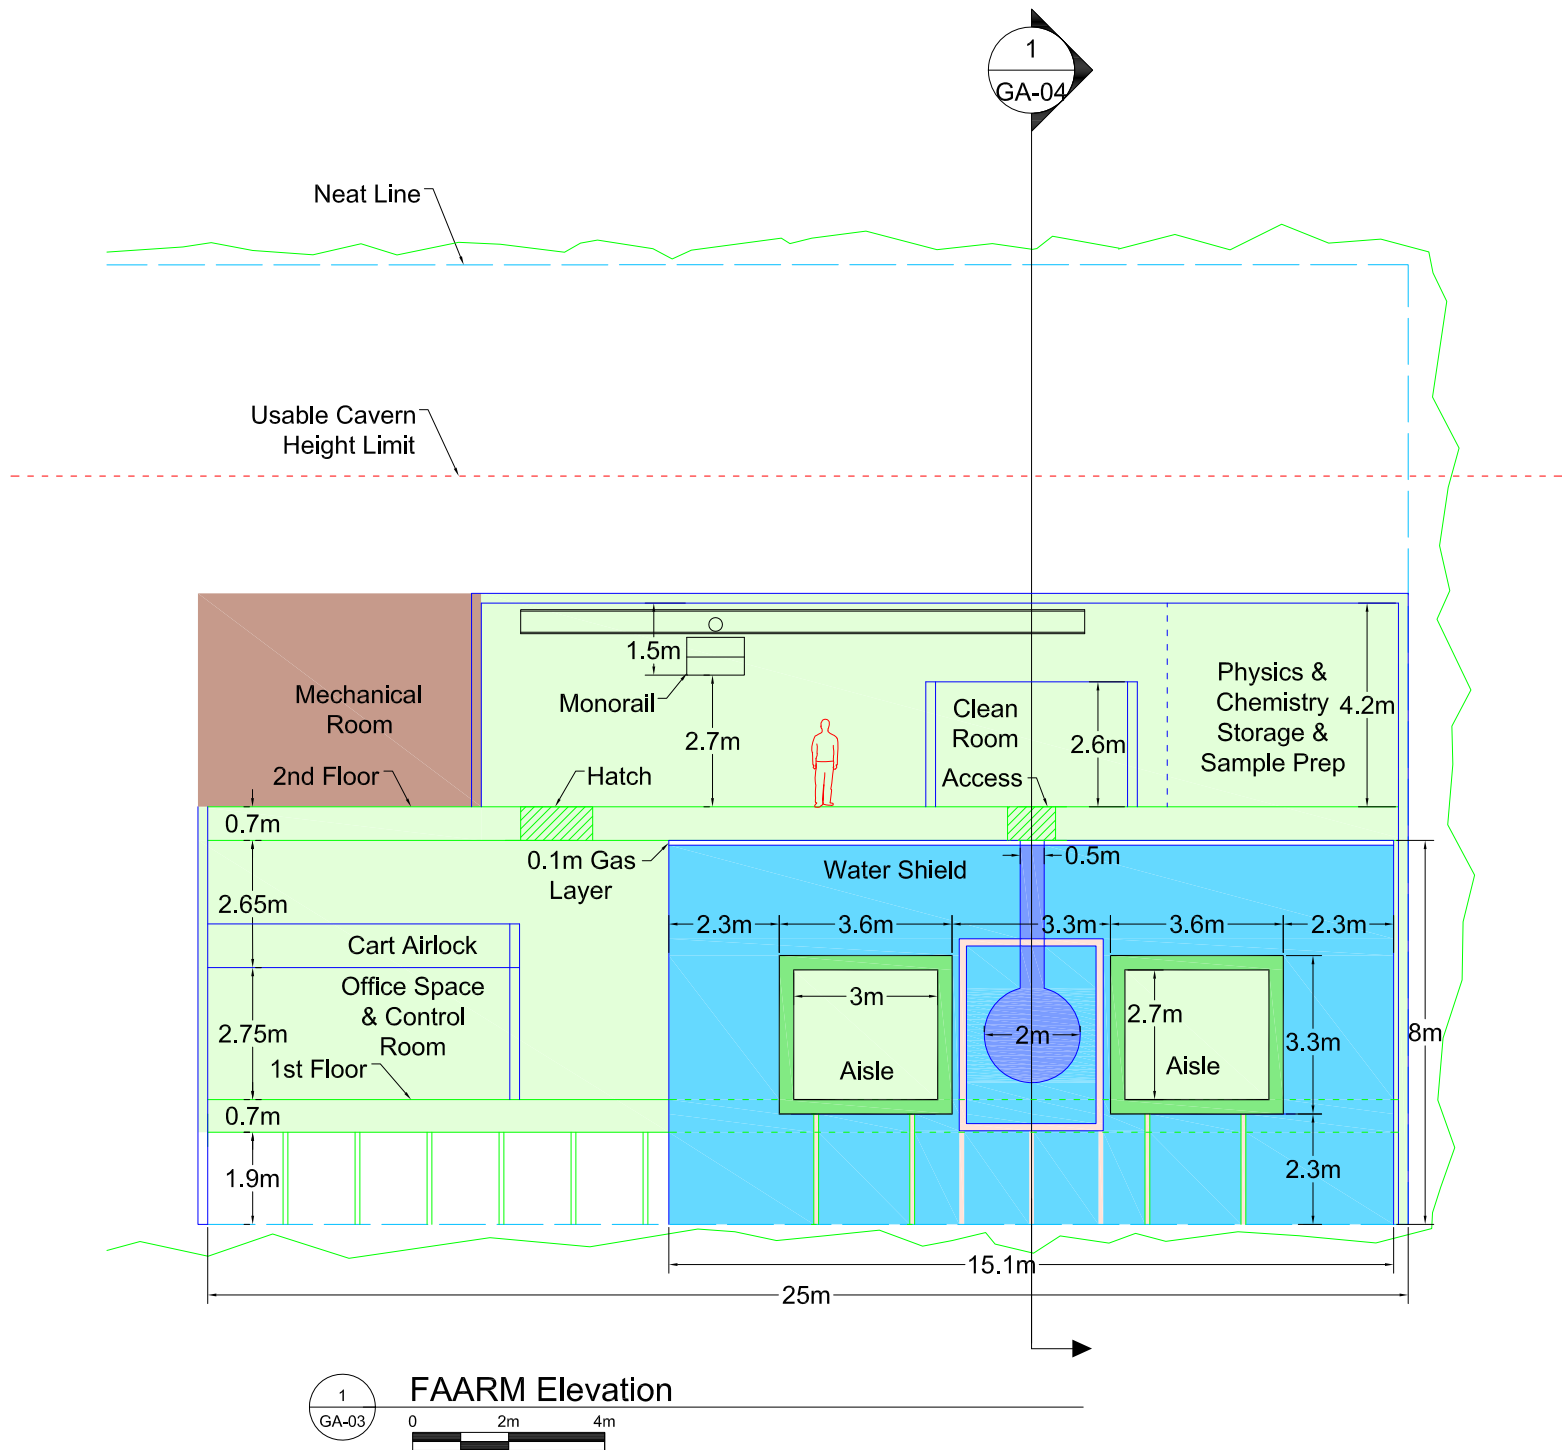
Transition Space

Water Shield
- Tank

Photomultiplier Tubes and Plumbing

Experiment Equipment

Support Structure



DRAFT
COPY

- Classified Space

Unclassified Space

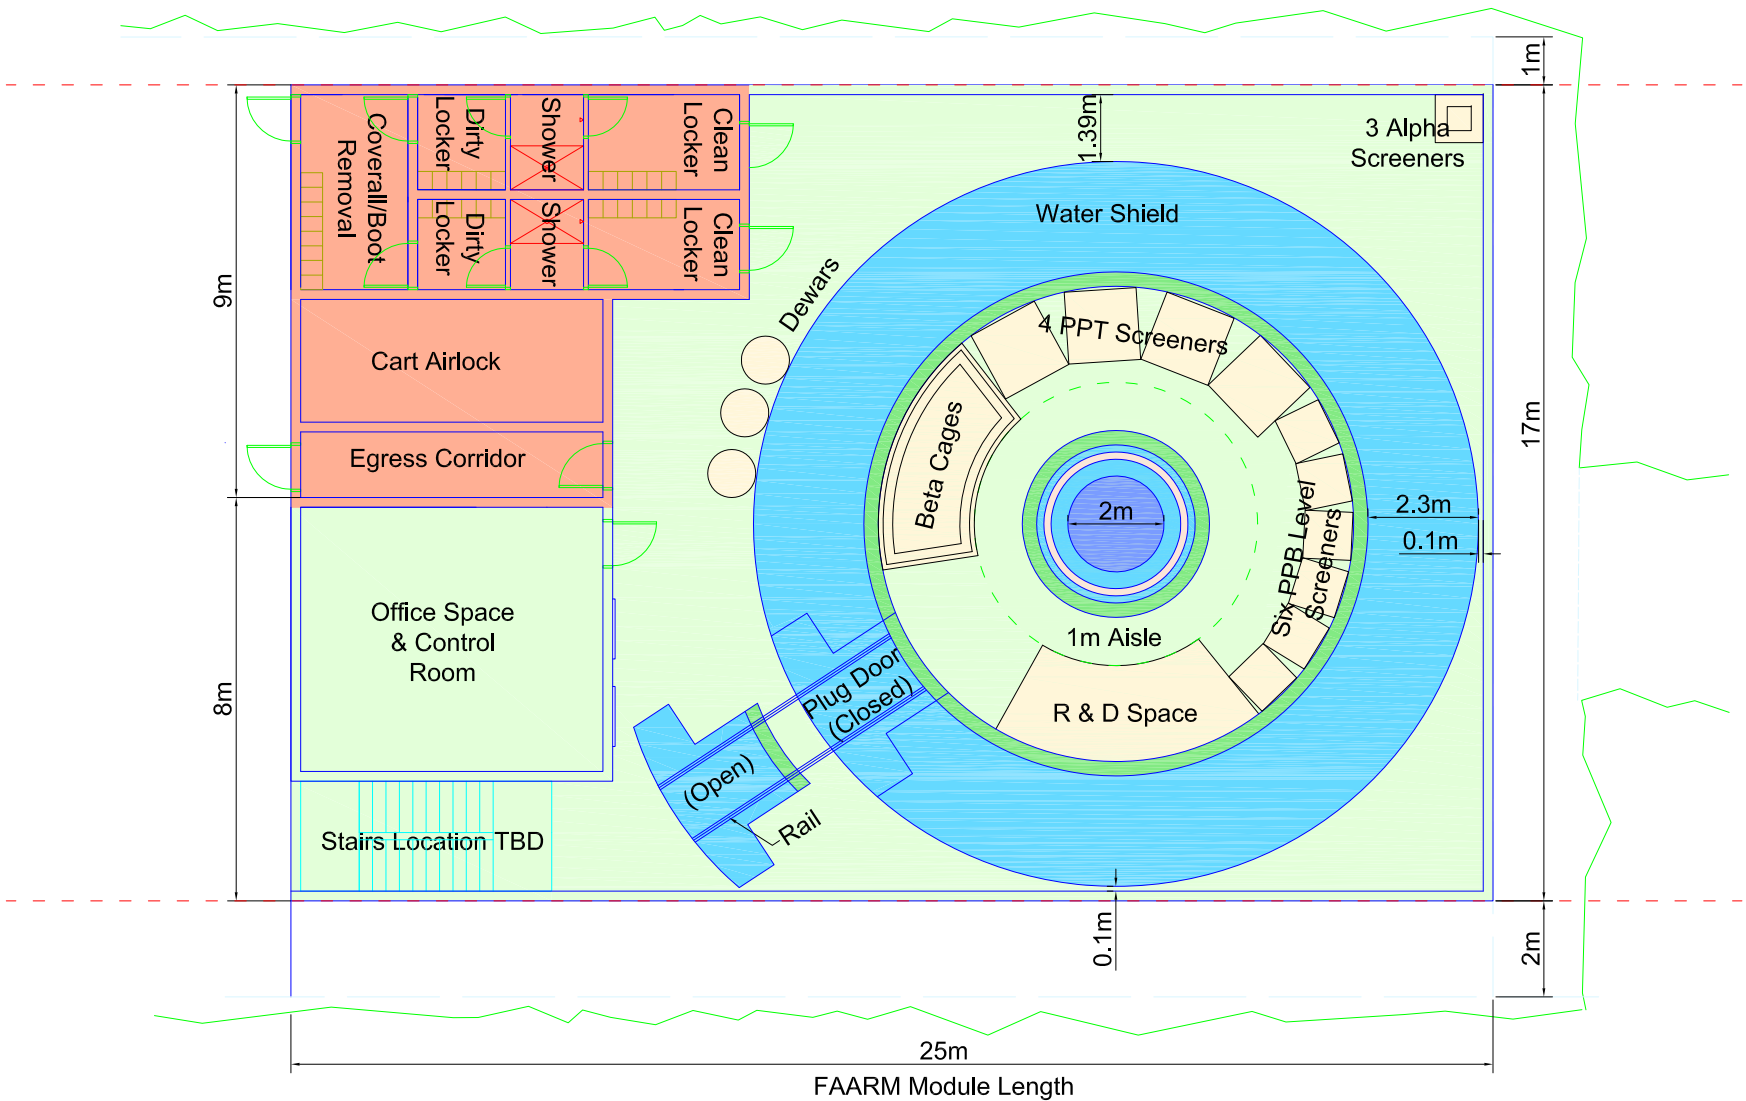
Transition Space

Water Shield
- Tank

Photomultiplier Tubes and Plumbing

Experiment Equipment

Support Structure



1
GA-01
First Floor Plan

DRAFT
COPY

Signature

X

Name

X

Date

X

License #

PROJECT:

UNIVERSITY OF MN

FAARM

CITY, STATE

REVISED

NO.	DATE	REMARK
#	#	#
#	#	#
COMM. NO.:

CNA0902

DATE:

April 02, 2010

DRAWN:

XXX

CHECKED:

XXX

DRAWING TITLE

DRAWING NUMBER:

GA-02

- Classified Space

Unclassified Space

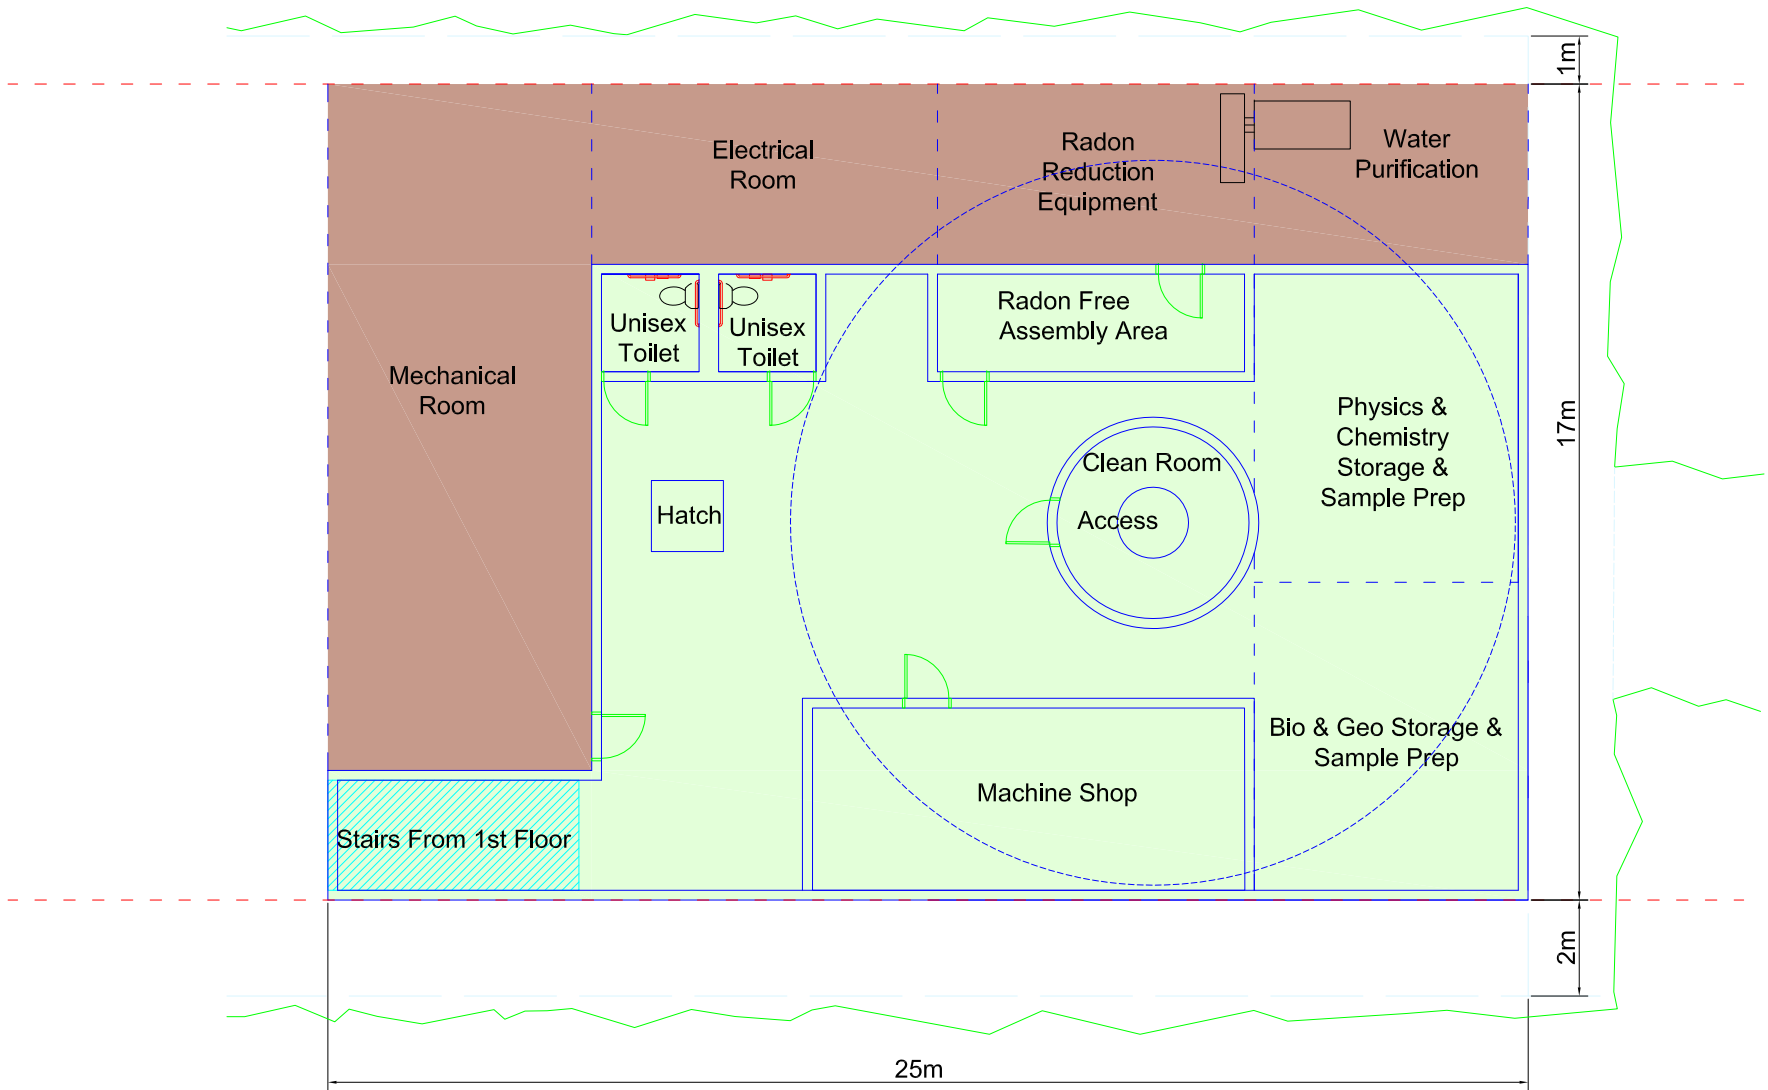
Transition Space

Water Shield
- Tank

Photomultiplier Tubes and Plumbing

Experiment Equipment

Support Structure



Second Floor Plan



DRAFT
COPY

PROJECT: _____

UNIVERSITY OF MN

FAARM

CITY, STATE

REVISED: _____

NO.	DATE	REMARK
#	#	#
#	#	#
COMM. NO.: CNA0902

DATE: April 02, 2010

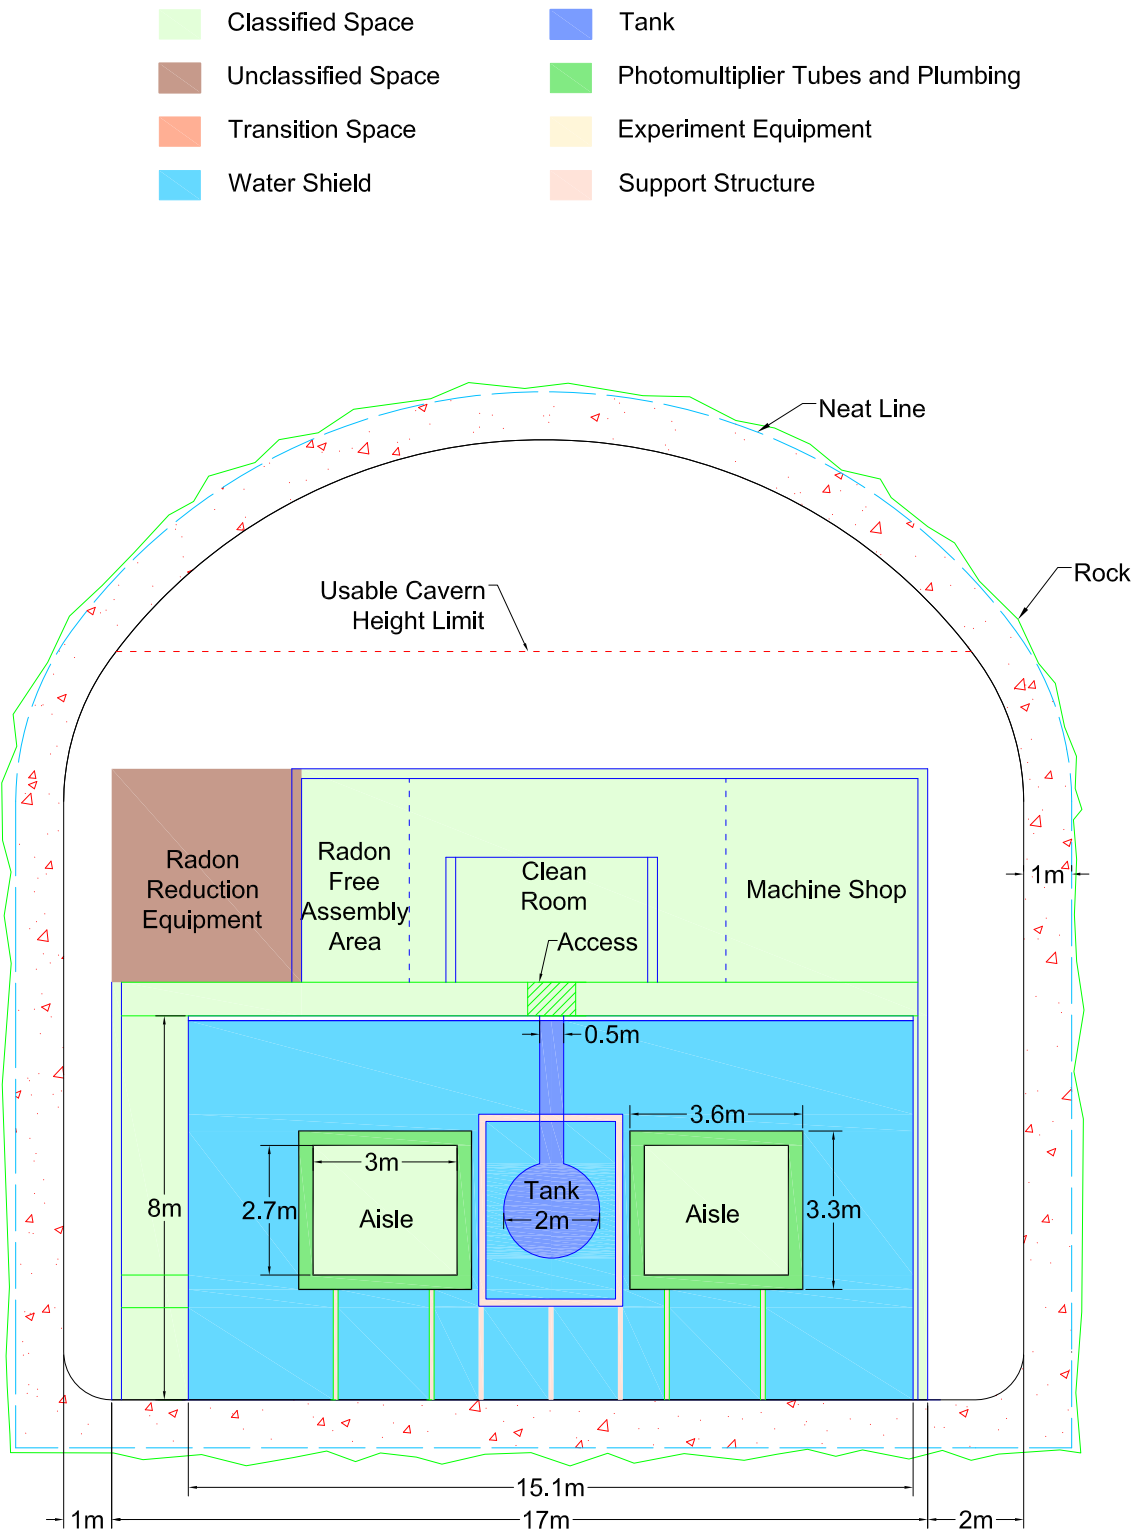
DRAWN: XXX

CHECKED: XXX

DRAWING TITLE: _____

DRAWING NUMBER: _____

GA-02



1
GA-04

Water Shield Section



DRAFT
COPY

Signature
X
Name
X
Date
X
License #

PROJECT

UNIVERSITY OF MN

FAARM

CITY, STATE

REVISED		
NO.	DATE	REMARK
#	#	#
#	#	#
COMM. NO.: CNA0902

DATE: April 02, 2010

DRAWN: XXX

CHECKED: XXX

DRAWING TITLE:

DRAWING NUMBER:

GA-04